



THE DIVISION OF CONTINUING EDUCATION

BENJAMIN THOMPSON & ASSOCIATES, INC. ARCHITECTURE, PLANNING, AND URBANISM ONE STORY STREET CAMBRIDGE, MA 02138 (617) 876-4800 FAX (617) 661-9213, 868-9023

Cosentini Consulting Engineers 44 Brattle Street Cambridge, Massachusetts 02138 (617) 876-3830 FAX (617) 876-6647

LeMessurier Consultants 1033 Massachusetts Avenue Cambridge, Massachusetts 02138 (617) 868-1200 FAX (617) 661-7520

RENOVATIONS TO 51 BRATTLE STREET

NOTE: SEE ARCHITECTURAL FOR REVISIONS ROOM (E-608)



KEY:

- 2 HR. WALL
- ▨ NEW MASONRY INFILL

NOTES:

1. LOCATE SMOKE DETECTOR BEYOND SWING OF DOOR.
2. ALL FIXTURES AND DEVICES SHALL BE LOCATED AS PER ARCHITECTURAL REFLECTED CEILING PLAN.

SIXTH LEVEL

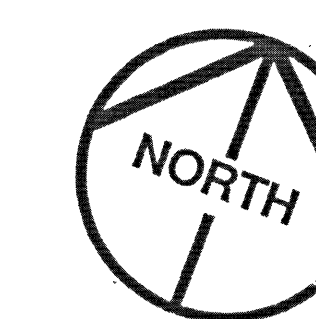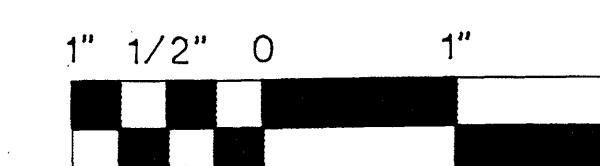

RECORD SET 15 SEPT. 1992

REVISION	DATE	DESCRIPTION
1	4-10-91	ROOM NAME & NUMBER REVISION
2	3-21-91	MISCELLANEOUS REVISION
3	2-20-91	MISCELLANEOUS REVISION
4	2-6-90	LIGHTING REVISION

SIXTH LEVEL LIGHTING PLAN		
DRAWN MWR	CHECKED	APPROVED
SCALE 1/4" = 1'-0"	DATE 10 AUG 90	JOB NO. 8912.00

E-12