





THE DIVISION  
OF  
CONTINUING EDUCATION

BENJAMIN THOMPSON & ASSOCIATES, INC.  
ARCHITECTURE, PLANNING, AND URBANISM  
ONE STORY STREET  
CAMBRIDGE, MA 02138  
(617) 876-4300 FAX (617) 661-9213, 868-9023

Cosentini Consulting Engineers  
44 Brattle Street  
Cambridge, Massachusetts 02138  
(617) 876-3830 FAX (617) 876-6647

LeMessurier Consultants  
1033 Massachusetts Avenue  
Cambridge, Massachusetts 02138  
(617) 868-1200 FAX (617) 661-7520

RENOVATIONS  
TO  
51 BRATTLE STREET

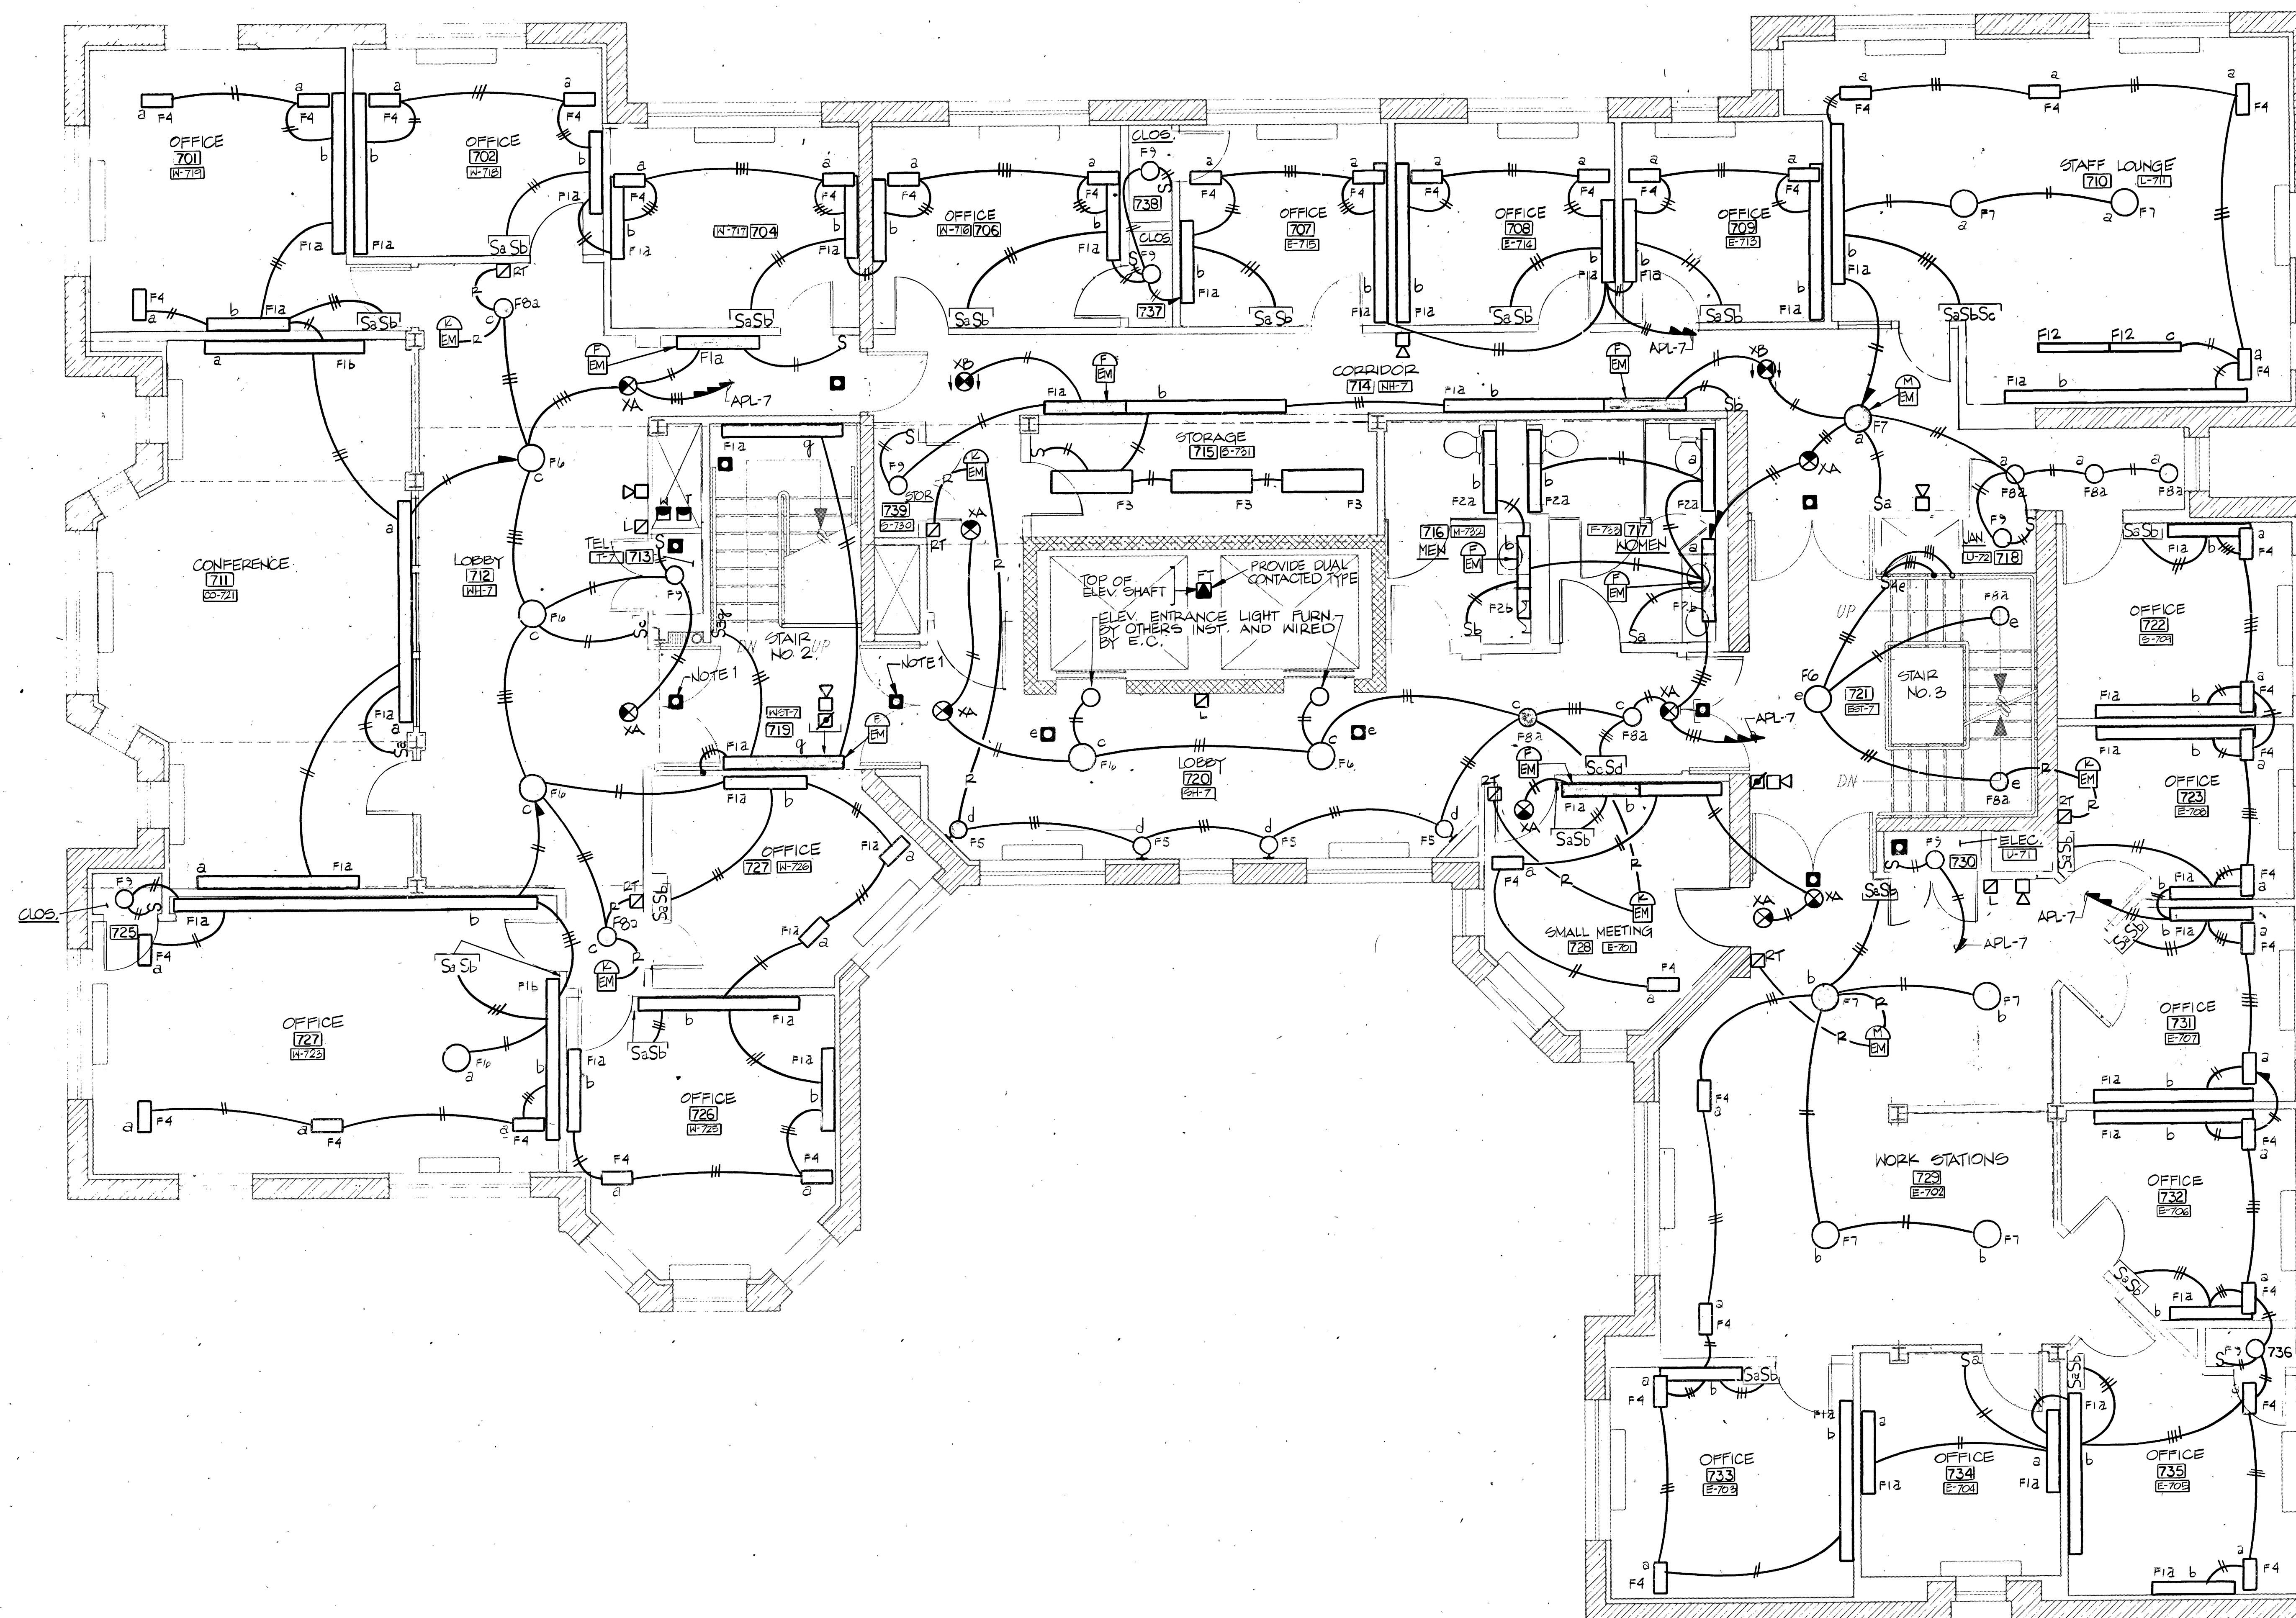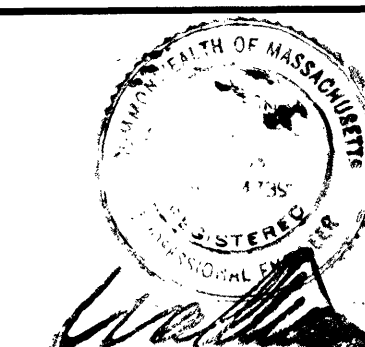

SEVENTH LEVEL

NOTES:

1. LOCATE SMOKE DETECTOR BEYOND SWING OF DOOR.
2. ALL FIXTURES AND DEVICES SHALL BE LOCATED AS PER ARCHITECTURAL REFLECTED CEILING PLAN.

RECORD SET 15 SEPT. 1992

REVISION	DATE	DESCRIPTION
4-10-91		ROOM NAMES & NUMBERS REVISION
4-1-91		DELETED SMOKE DETECTOR AND ADDED HEAT DETECTOR IN ELEVATOR SHAFT
3-21-91		MISCELLANEOUS REVISION
2-20-91		MISCELLANEOUS REVISION
12-6-90		LIGHTING REVISION

SEVENTH LEVEL  
LIGHTING PLAN

DRAWN R.T./	CHECKED M.T./	APPROVED
SCALE 1/4" = 1'-0"	DATE 8/15/90	JOB NO. 8912.00

E-14

