




THE DIVISION
OF
CONTINUING EDUCATION

BENJAMIN THOMPSON & ASSOCIATES, INC.
ARCHITECTURE, PLANNING, AND URBANISM
ONE STORY STREET
CAMBRIDGE, MA 02138
(617) 876-4300 FAX (617) 661-9218, 868-9023

Consentini Consulting Engineers
14 Brattle Street
Cambridge, Massachusetts 02138
(617) 876-3930 FAX (617) 876-6647

eMessurier Consultants
1033 Massachusetts Avenue
Cambridge, Massachusetts 02138
(617) 868-1200 FAX (617) 661-1520

RENOVATIONS
TO
51 BRATTLE STREET

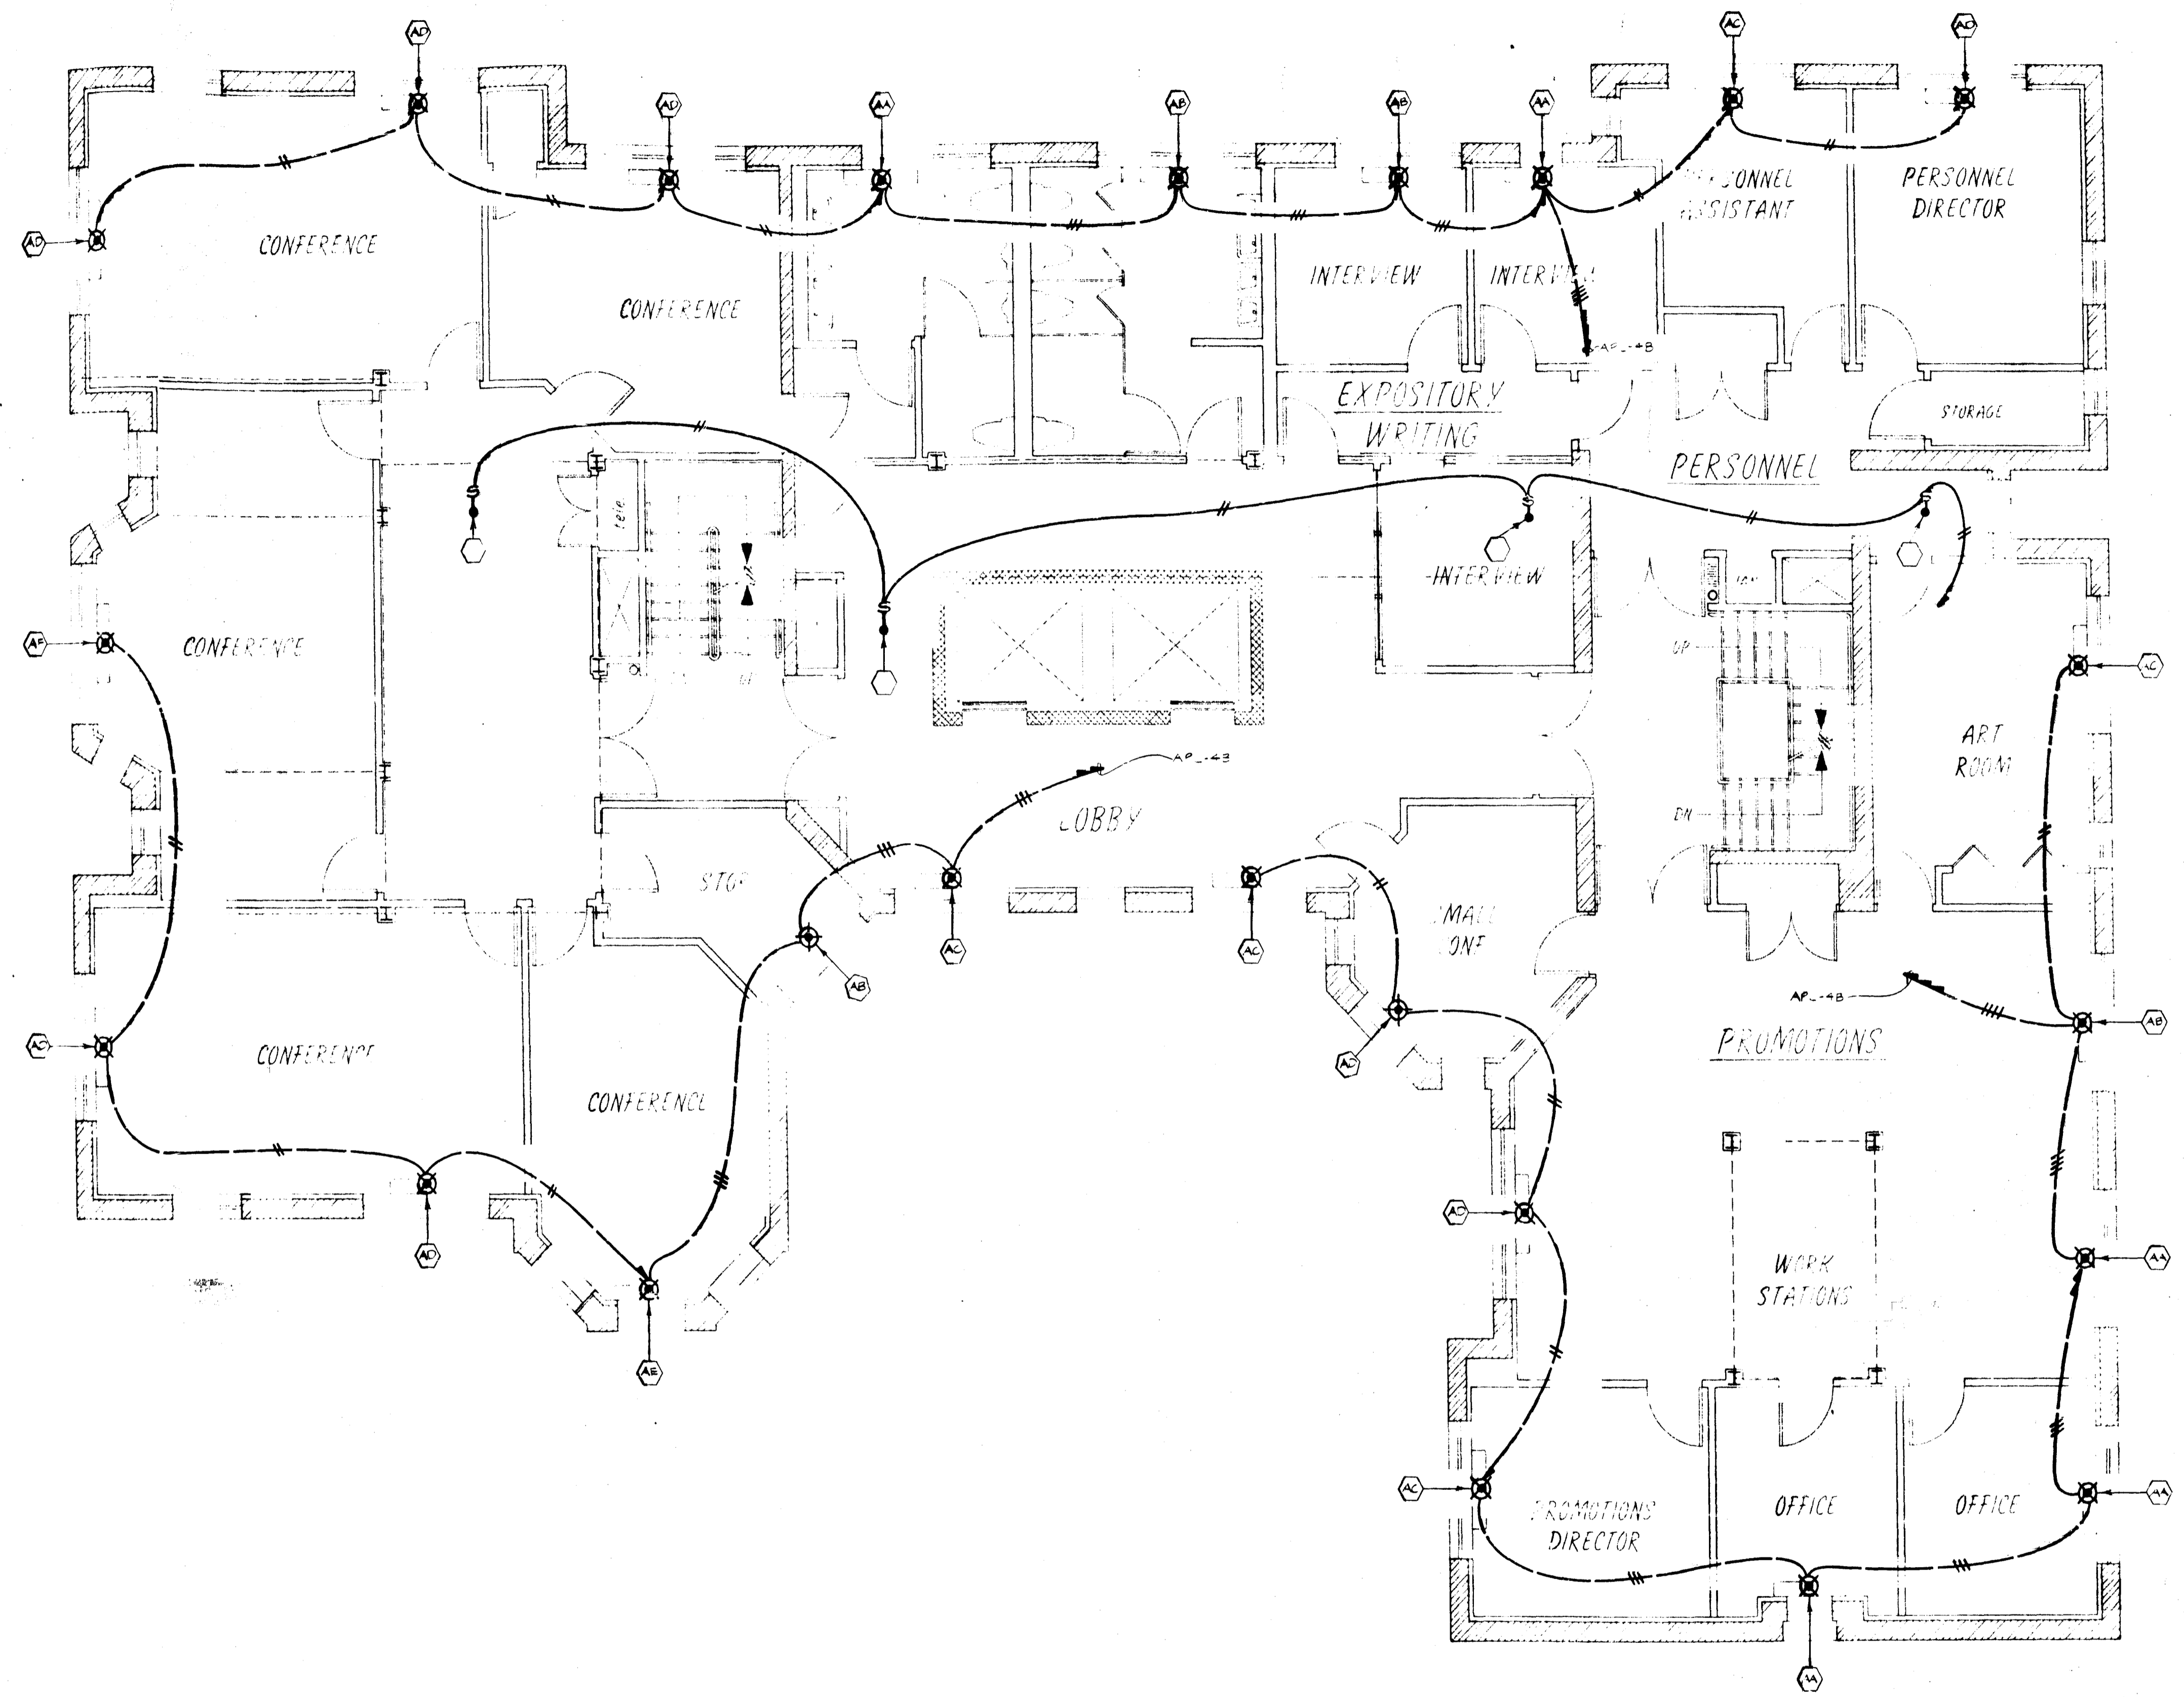

THIRD LEVEL

DESIGN DEVELOPMENT 3-21-90

REVISION	DATE	DESCRIPTION
THIRD LEVEL POWER PLAN		
DRAWN R.T.	CHECKED M.T.	APPROVED
SCALE 1/4" = 1'-0"	DATE	JOB NO. 8912.00

E-7
220-47