




THE DIVISION OF CONTINUING EDUCATION

BENJAMIN THOMPSON & ASSOCIATES, INC. ARCHITECTURE, PLANNING, AND URBANISM ONE STORY STREET CAMBRIDGE, MA 02138 (617) 876-4300 FAX (617) 661-9213, 868-9023

Coventini Consulting Engineers 44 Brattle Street Cambridge, Massachusetts 02138 (617) 876-3830 FAX (617) 876-6647

LeMessurier Consultants 1033 Massachusetts Avenue Cambridge, Massachusetts 02138 (617) 868-1200 FAX (617) 661-7520

RENOVATIONS TO 51 BRATTLE STREET

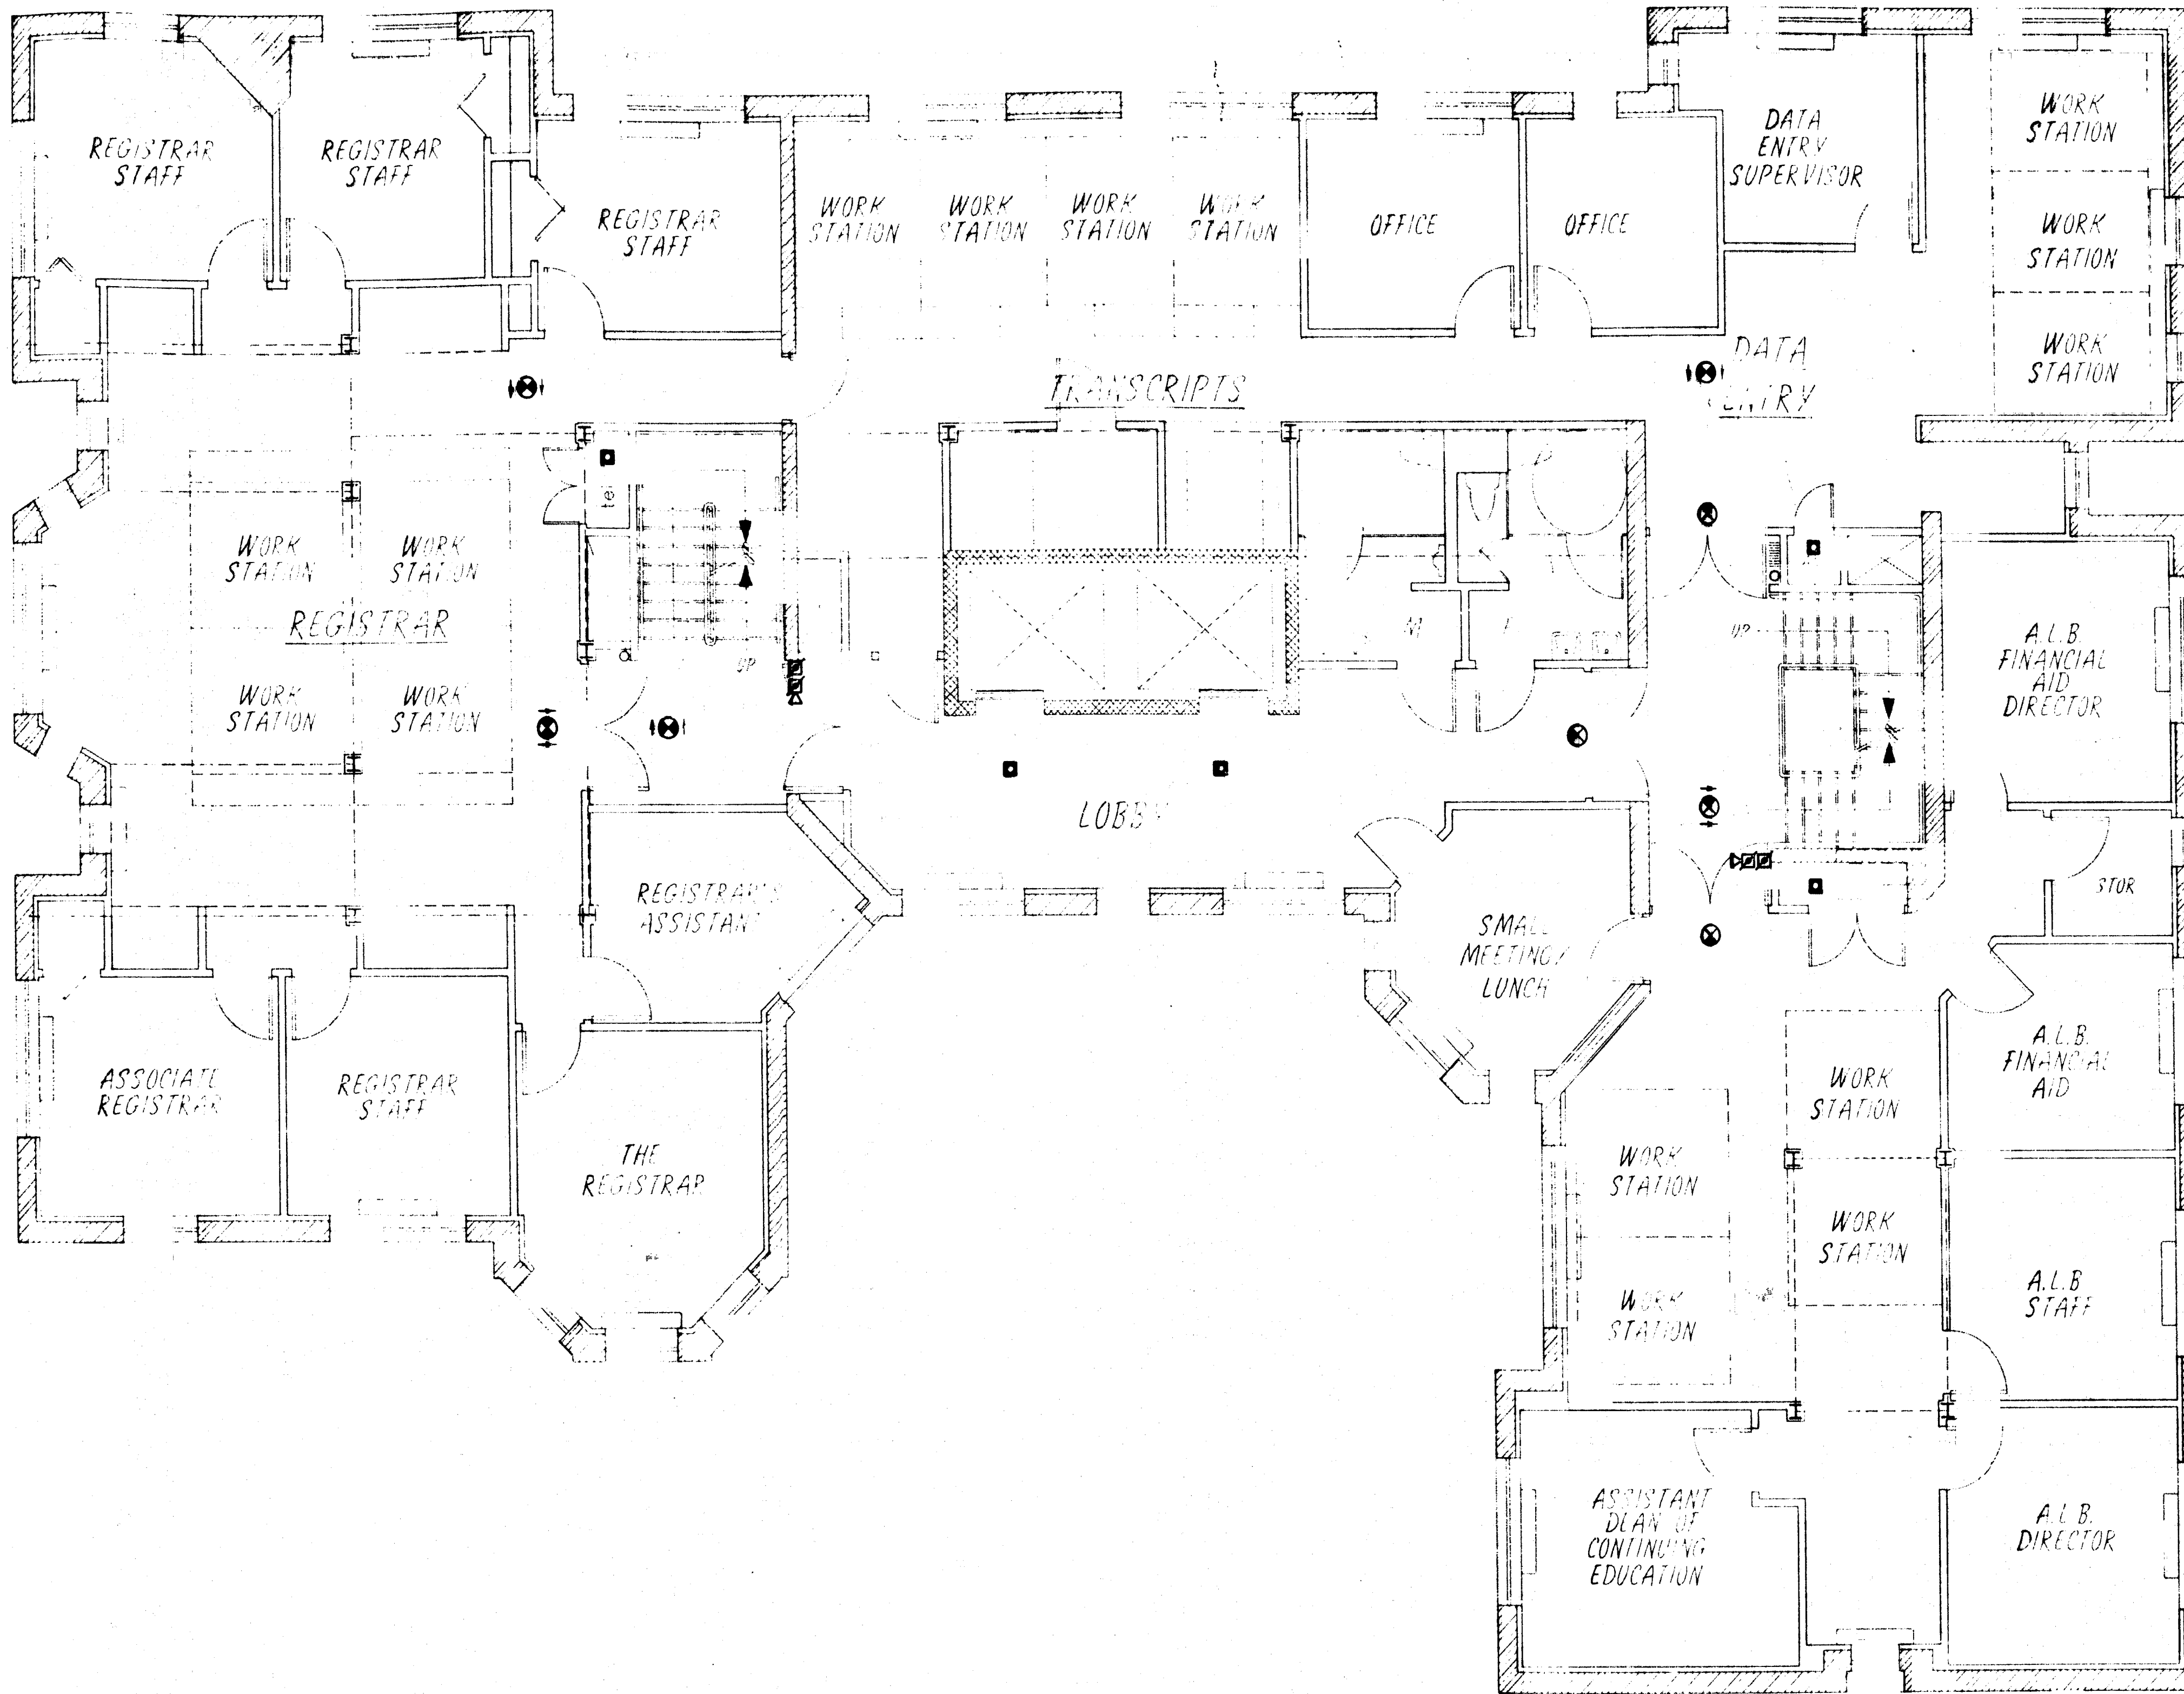

SIXTH LEVEL

DESIGN DEVELOPMENT 3-21-90

REVISION DATE DESCRIPTION

SIXTH LEVEL LIGHTING PLAN

DRAWN	CHECKED	APPROVED
R.I.	M.T.	
SCALE	DATE	JOB NO.
1/4"=1'-0"		8912.00

E-12

220-52