

IFP

INFINITY FIRE PROTECTION, INC.

61 ENDICOTT STREET
NORWOOD, MA 02062
781-769-5900(P)
781-769-4025(F)

[Contractor]
LEE KENNEDY CO

[Designer] IFP

[Job Number] 2122

[Authority] CITY OF CAMBRIDGE

[Job Name]
HARVARD UNIVERSITY
53 / 53A CHURCH STREET
CAMBRIDGE, MA



[Design Area]
ATTIC LEVEL
SPRINKLER PLAN

P.E. Stamp

Scale: 1/8" = 1'-0"

[Date] AUGUST 24, 2001

SP-3

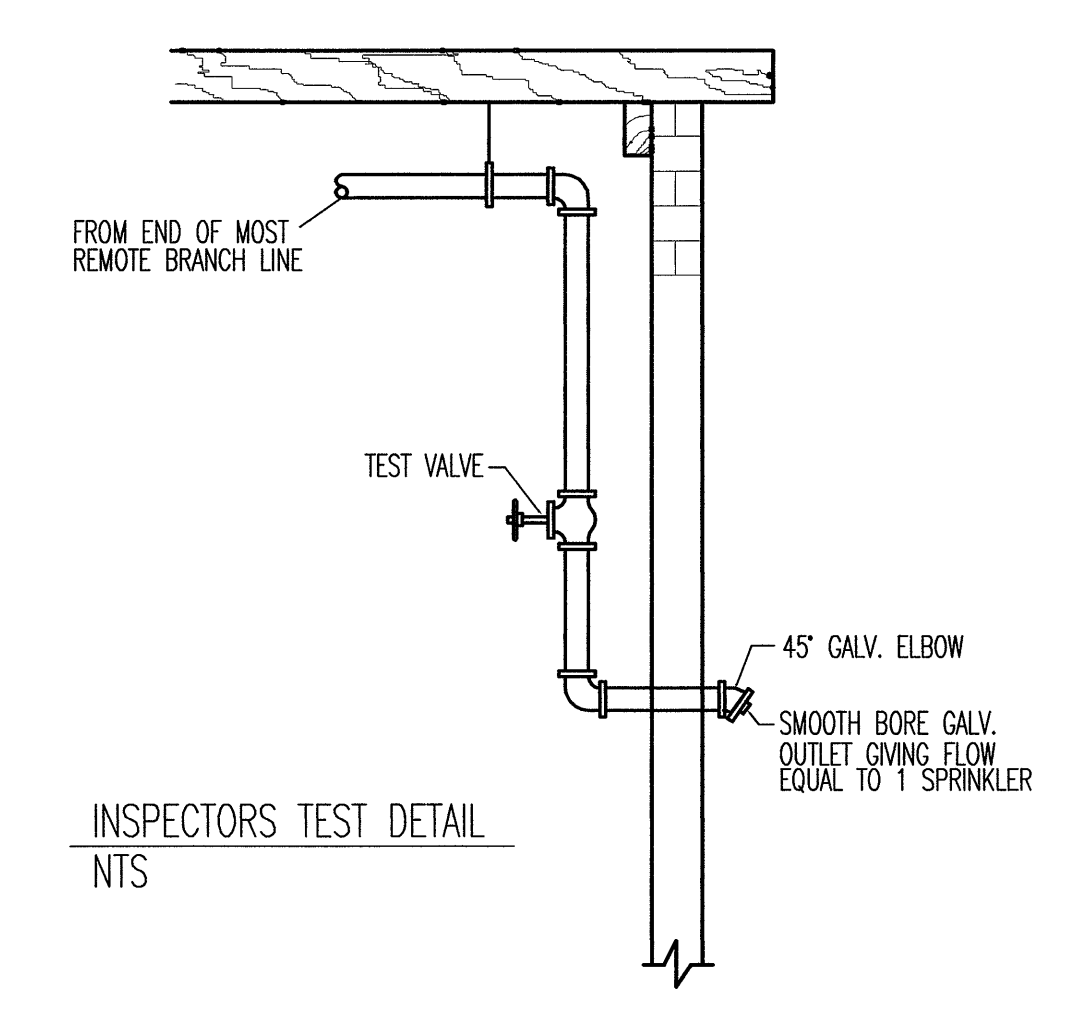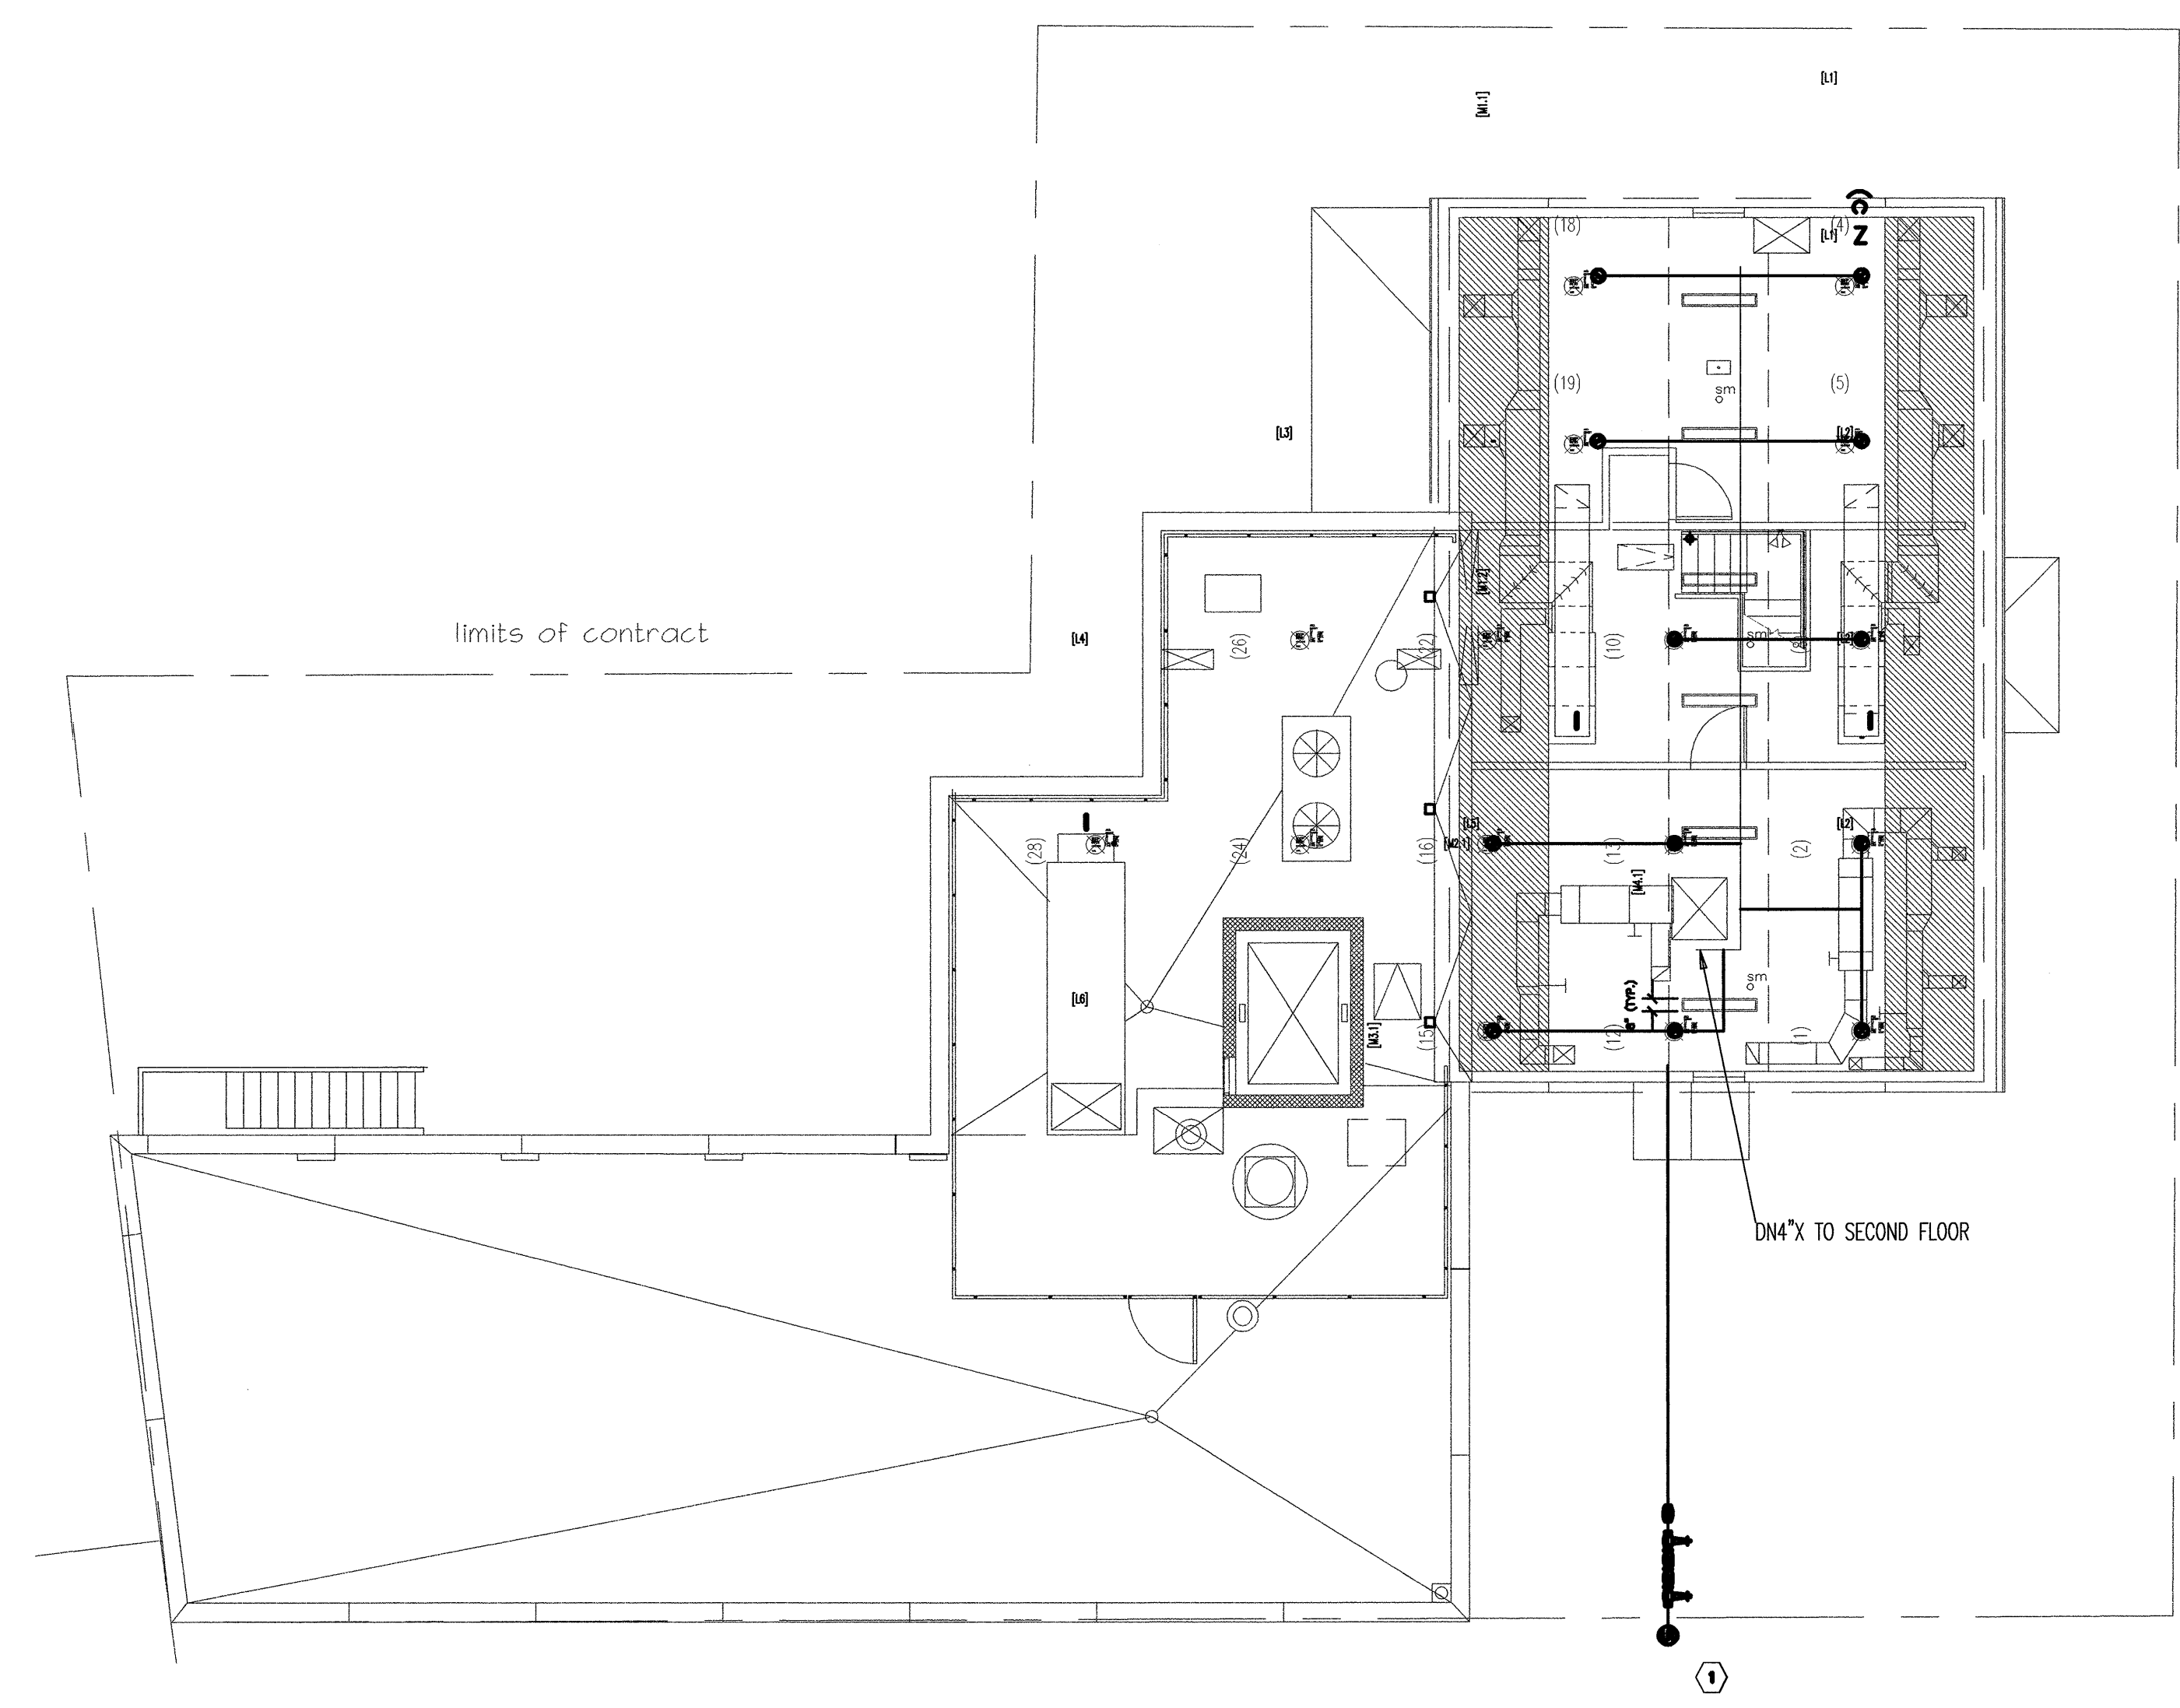

Attic Floor Sprinkler Plan