

KENNEDY  
SCHOOL of  
GOVERNMENT

HARVARD  
UNIVERSITY

FORUM

RENOVATION

SCALE: 1/8" = 1'-0"

JOB NO: 0135


DATE: JUNE 23, 2003

DRAWN: WMH

FILE NAME: X/KSG/CURRENT/0135

REVISIONS: 2

NO.	DESCRIPTION	DATE
2	FINAL REVISIONS	09/02/03
1	REVISIONS TO DATE	6/23/03

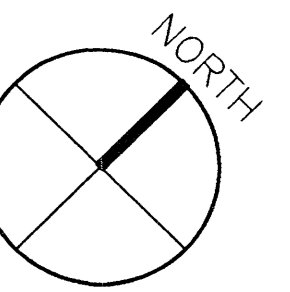


GROUND  
FLOOR RCP

ARCHITECTURAL  
RESOURCES  
CAMBRIDGE INC

140 MOUNT AUBURN ST  
CAMBRIDGE MA 02138  
TEL. (617) 547-2200  
FAX. (617) 547-7222

A-8.01

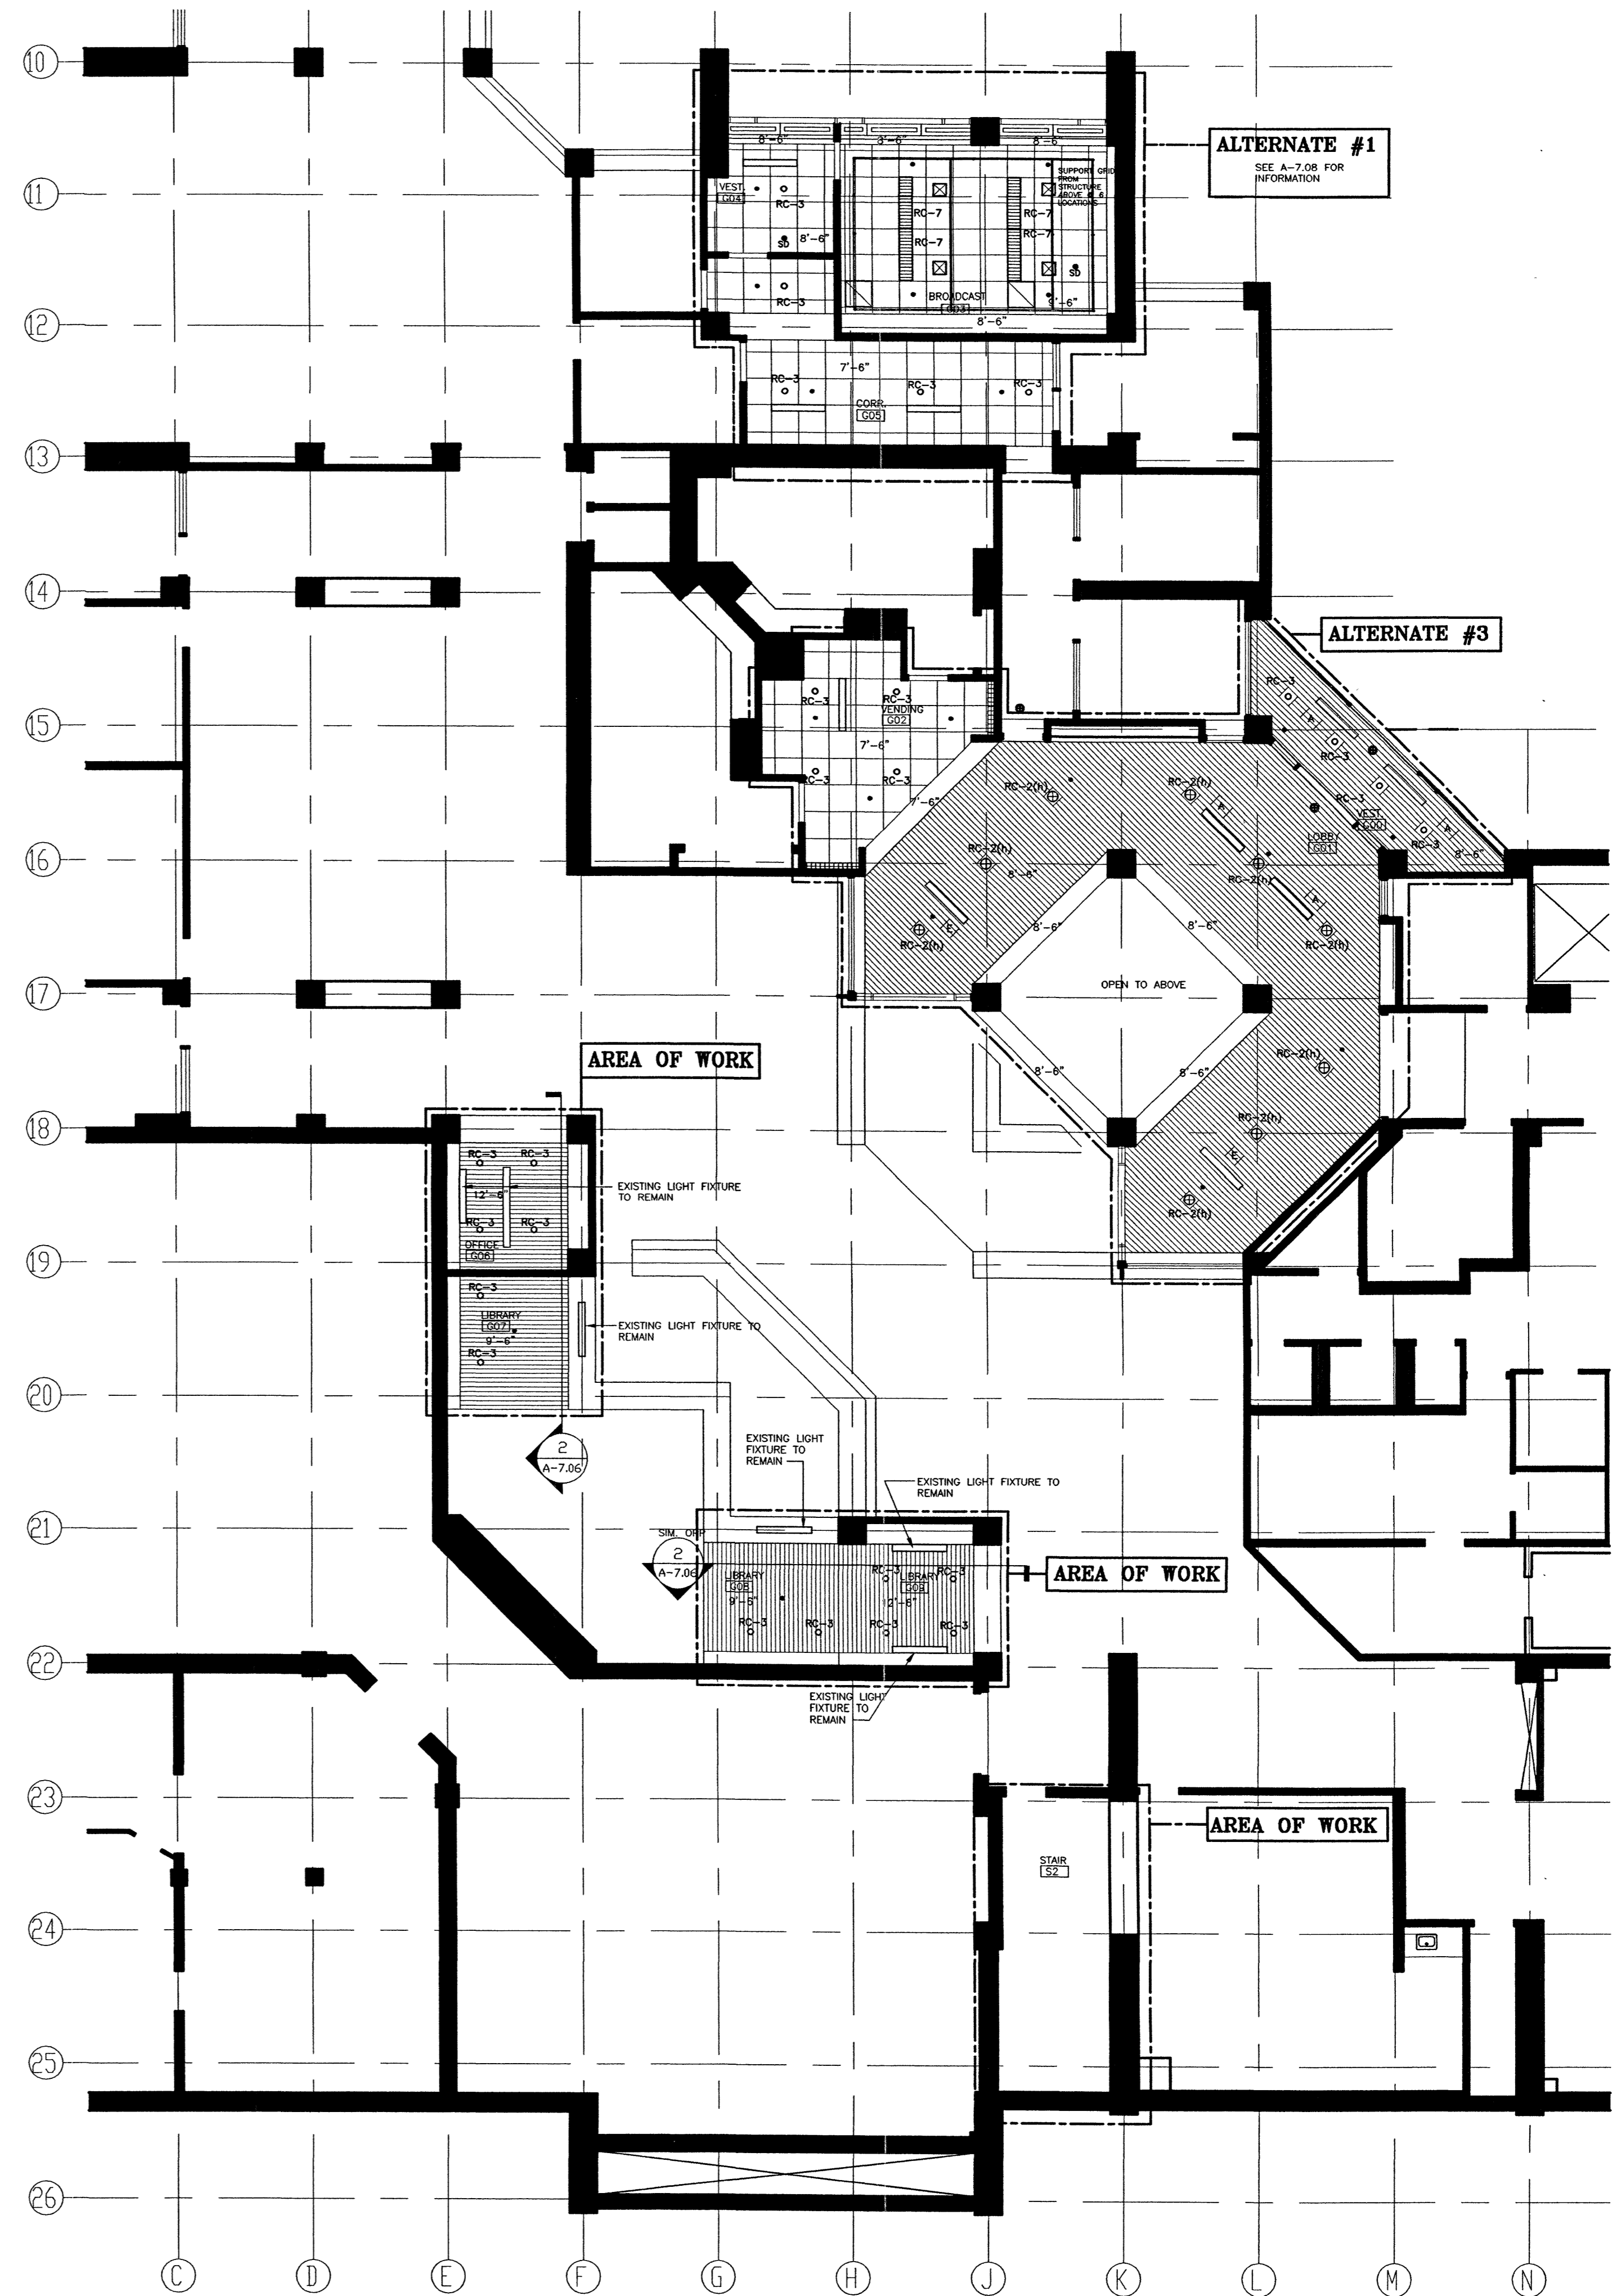

RCP LEGEND	
	RECESSED DOWNLIGHT
	RECESSED WALLWASHER
	SEMI-RECESSED DOWNLIGHT
	LINEAR
	SECURITY CAMERA
	EXIT SIGN
	SMOKE DETECTOR
	SPRINKLER
	SURFACE MOUNTED LIGHT FIXTURE
	CEILING DIFFUSER
	PIPE RAIL
	BROADCAST LIGHT FIXTURE
	RECESSED CEILING SPEAKER
	RECESSED A/V EQUIPMENT

2 RCP LEGEND  
N.T.S.

1 GROUND FLOOR REFLECTED CEILING PLAN  
1/8" = 1'-0"