

KENNEDY SCHOOL of GOVERNMENT

HARVARD UNIVERSITY

ACCESSIBILITY PROJECT

RENOVATION

SCALE: 1/4"=1'-0"

JOB NO: 02-2027

DATE: 07/12/02

DRAWN: PMT

FILE NAME: 2027m102

REVISIONS: ###

NO.	DESCRIPTION	DATE

BELFER BLD'G PLUMBING PLAN

TMP CONSULTING ENGINEERS INC.



52 TEMPLE PLACE  
BOSTON MA 02111  
TEL. (617) 357-6060  
FAX. (617) 357-5188

ARCHITECTURAL RESOURCES CAMBRIDGE INC

140 MOUNT AUBURN ST  
CAMBRIDGE MA 02138  
TEL. (617) 547-2200  
FAX. (617) 547-7222

Drawing #

**P-1.02**

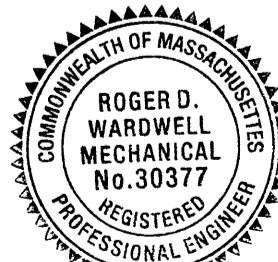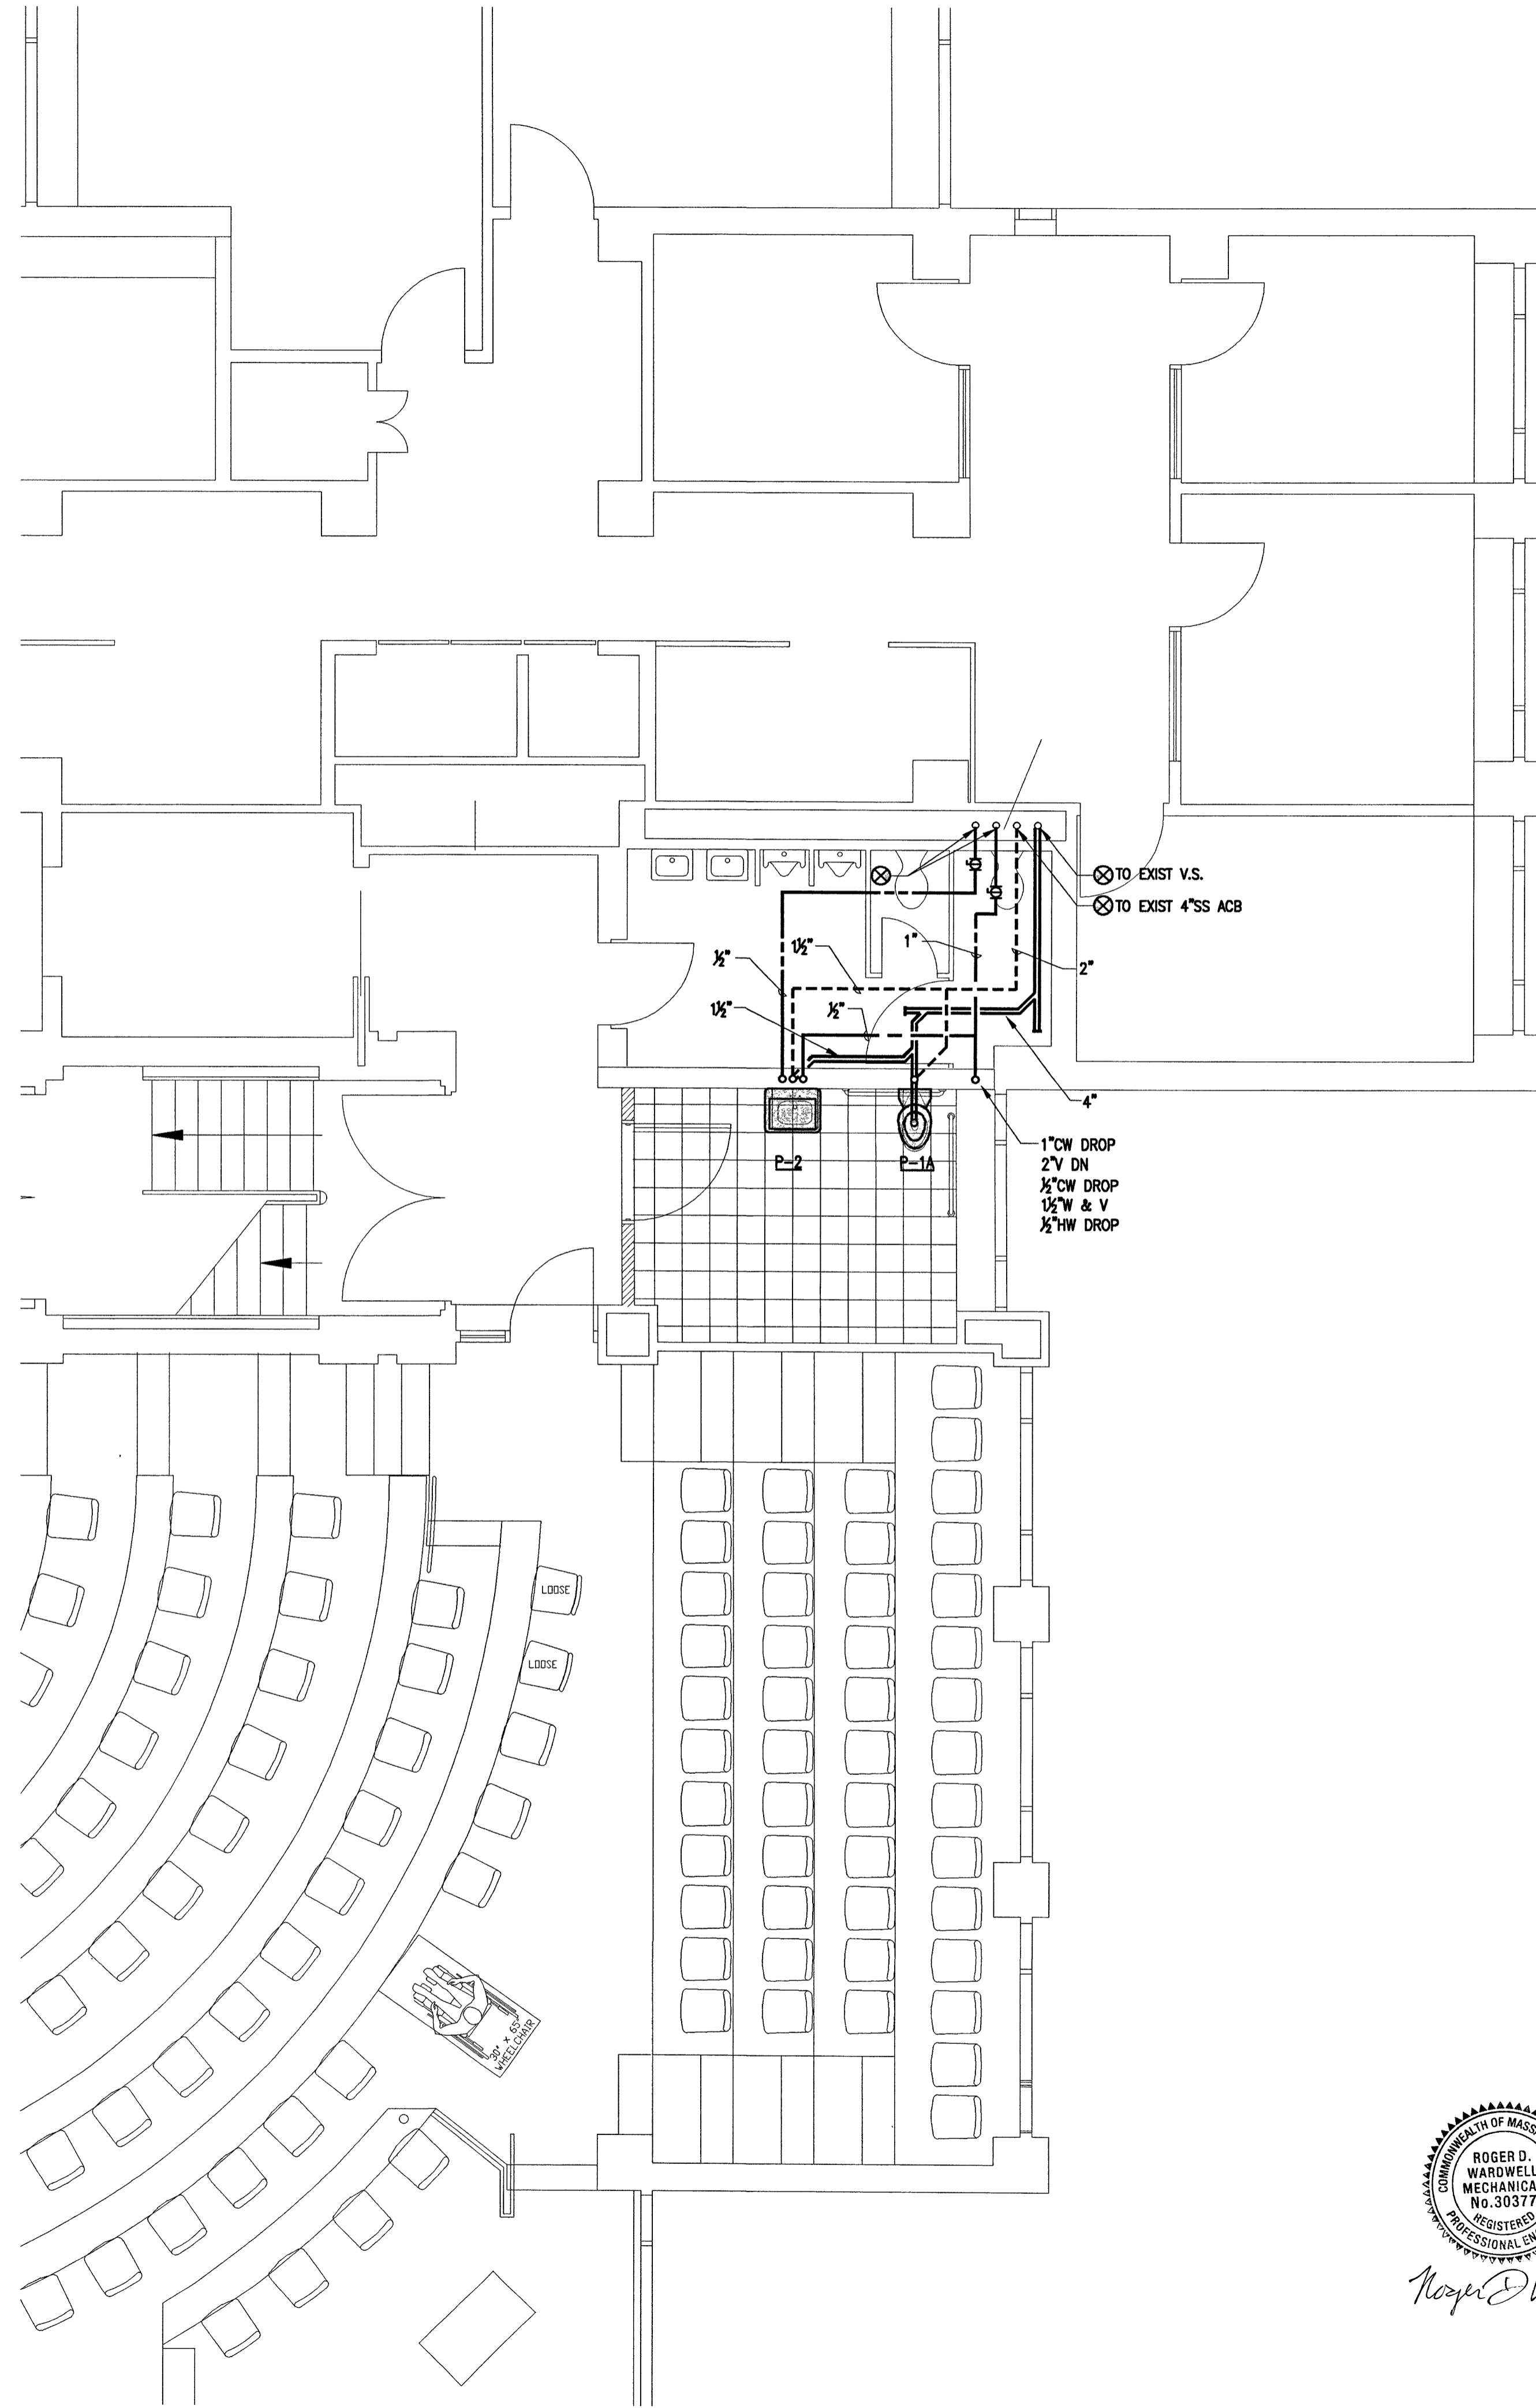

*Roger D. Wardwell*

Job 5038 ✓