




GROUND LEVEL MECHANICAL ROOM
DUCTWORK PLAN
1/4"=1'-0"

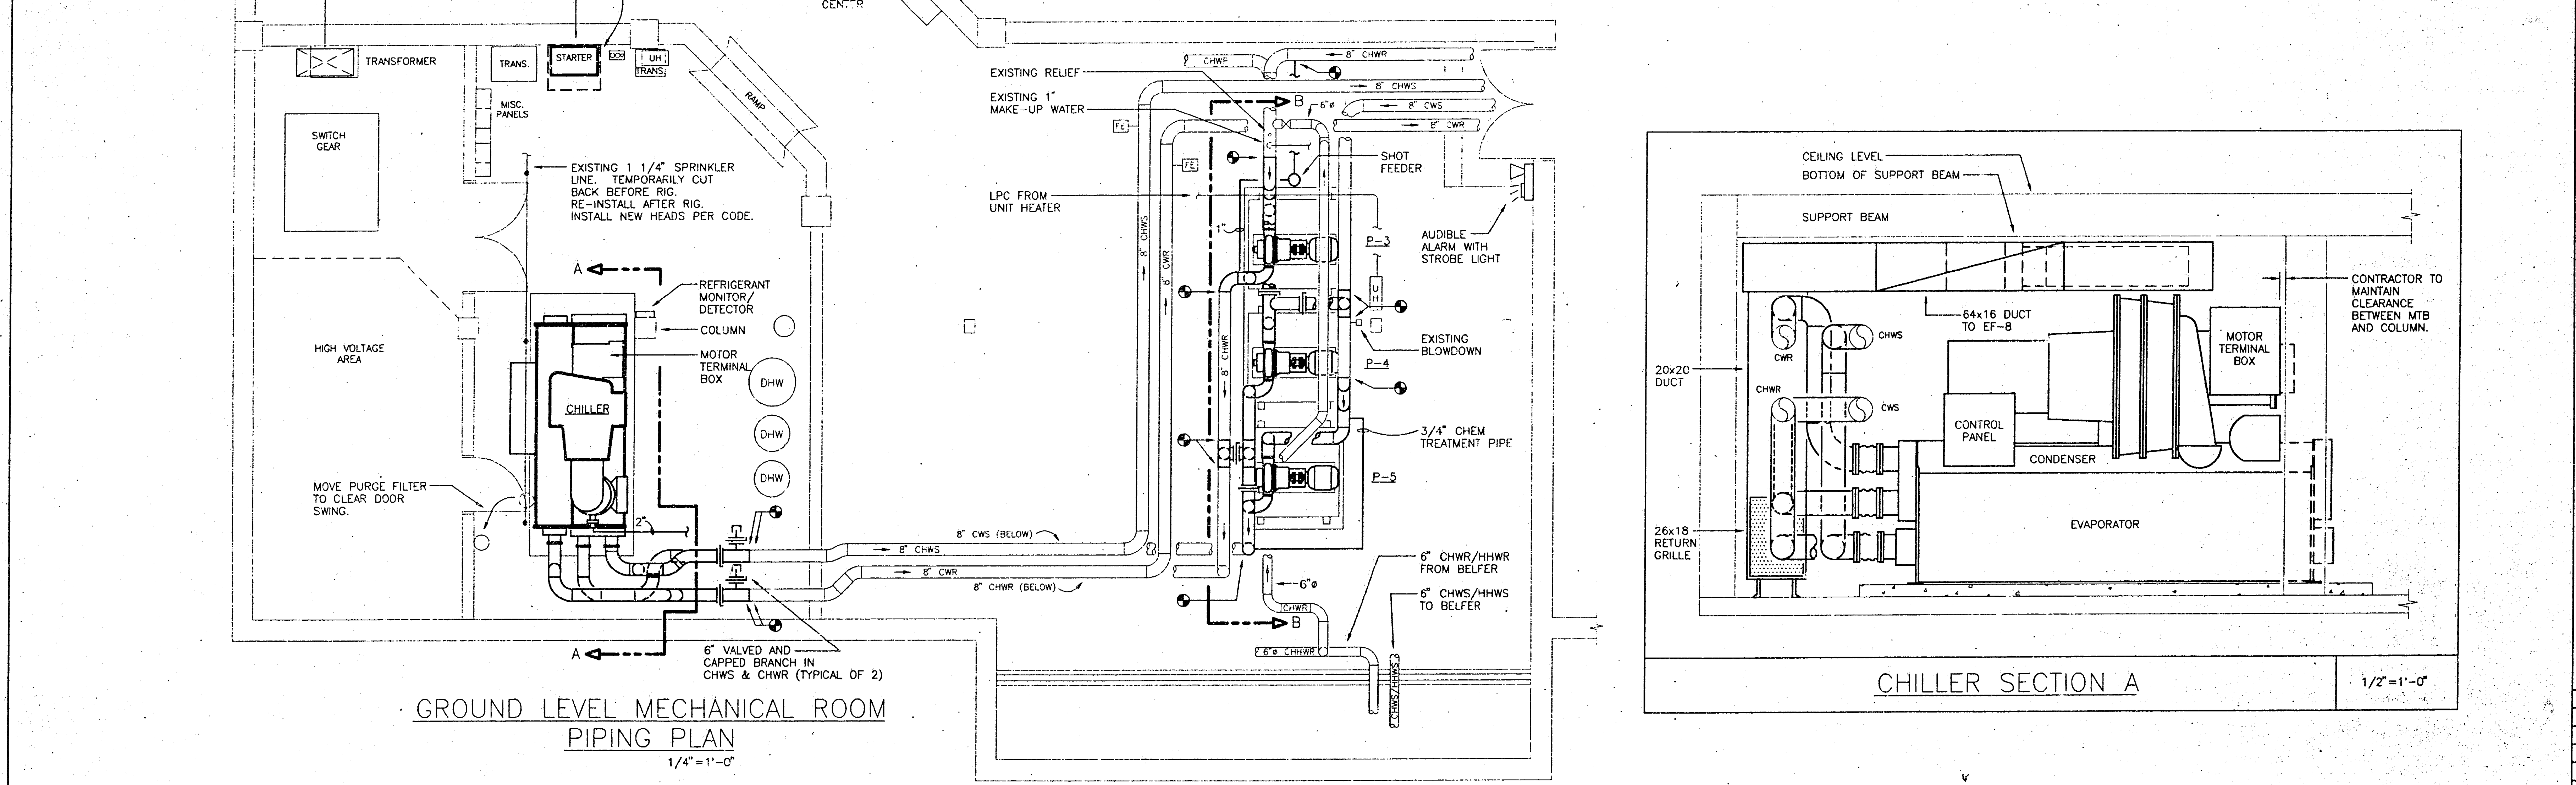

GROUND LEVEL MECHANICAL ROOM
PIPING PLAN
1/4"=1'-0"

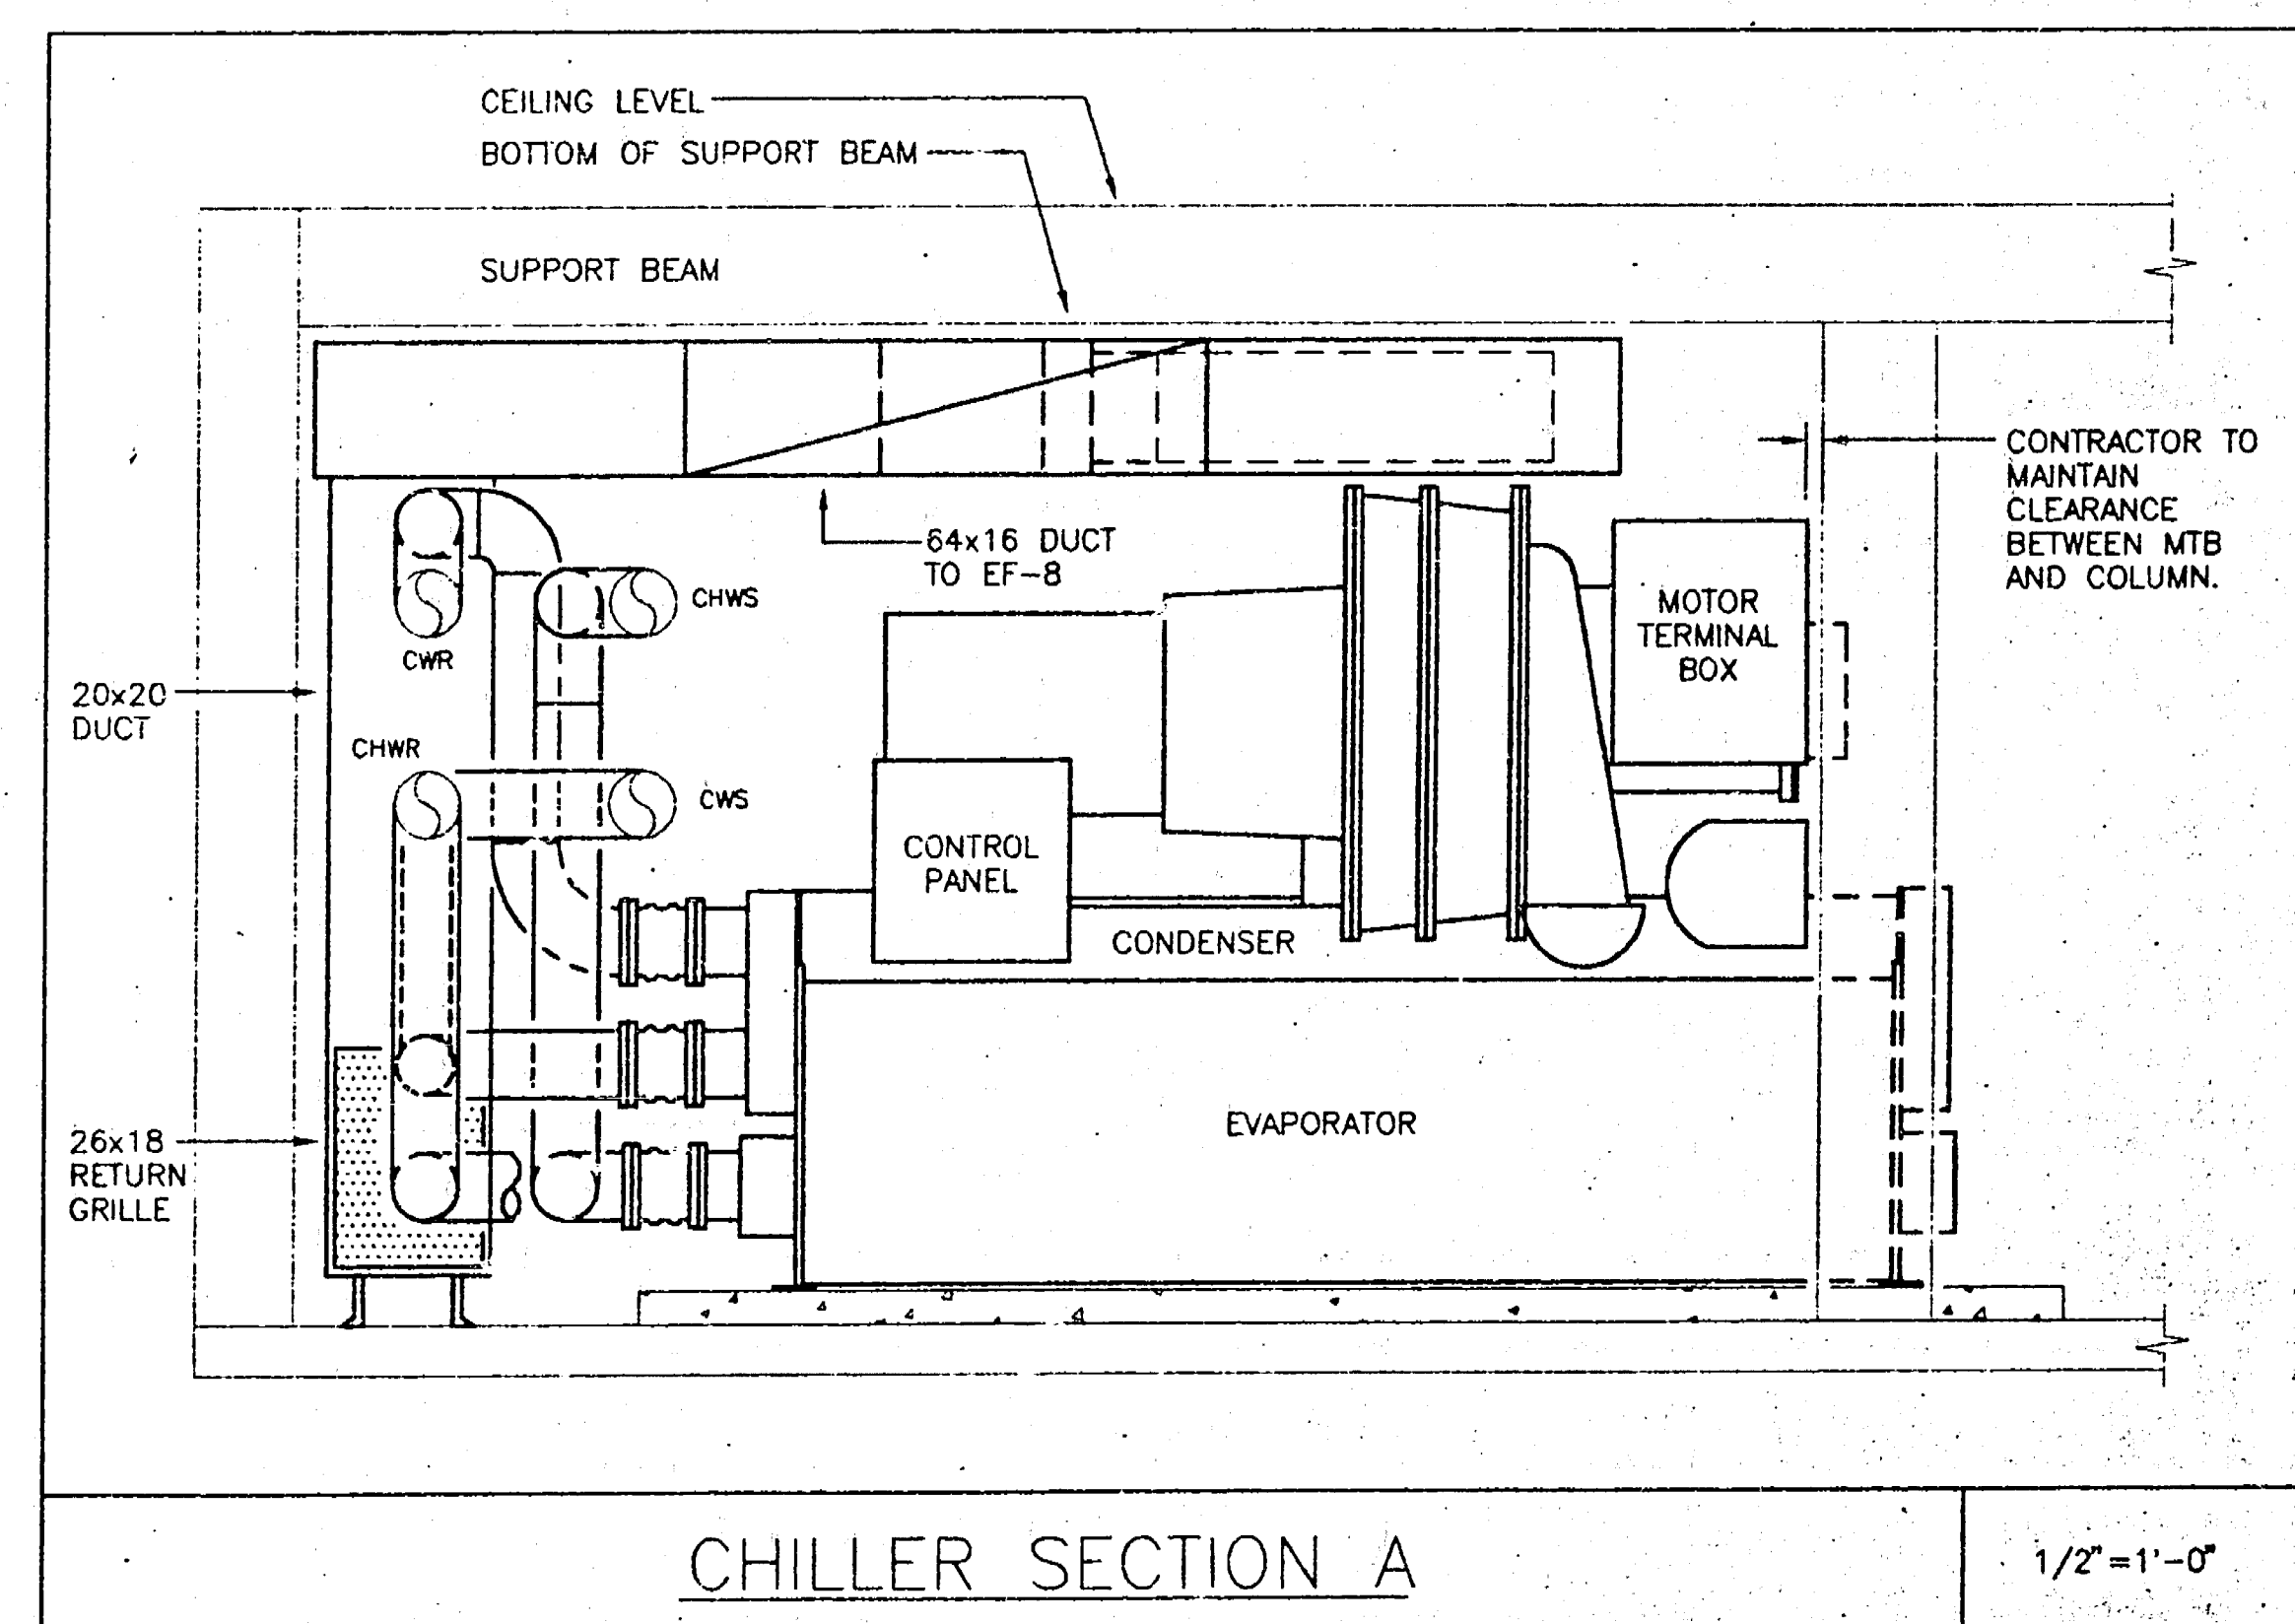

CHILLER SECTION A
1/2"=1'-0"

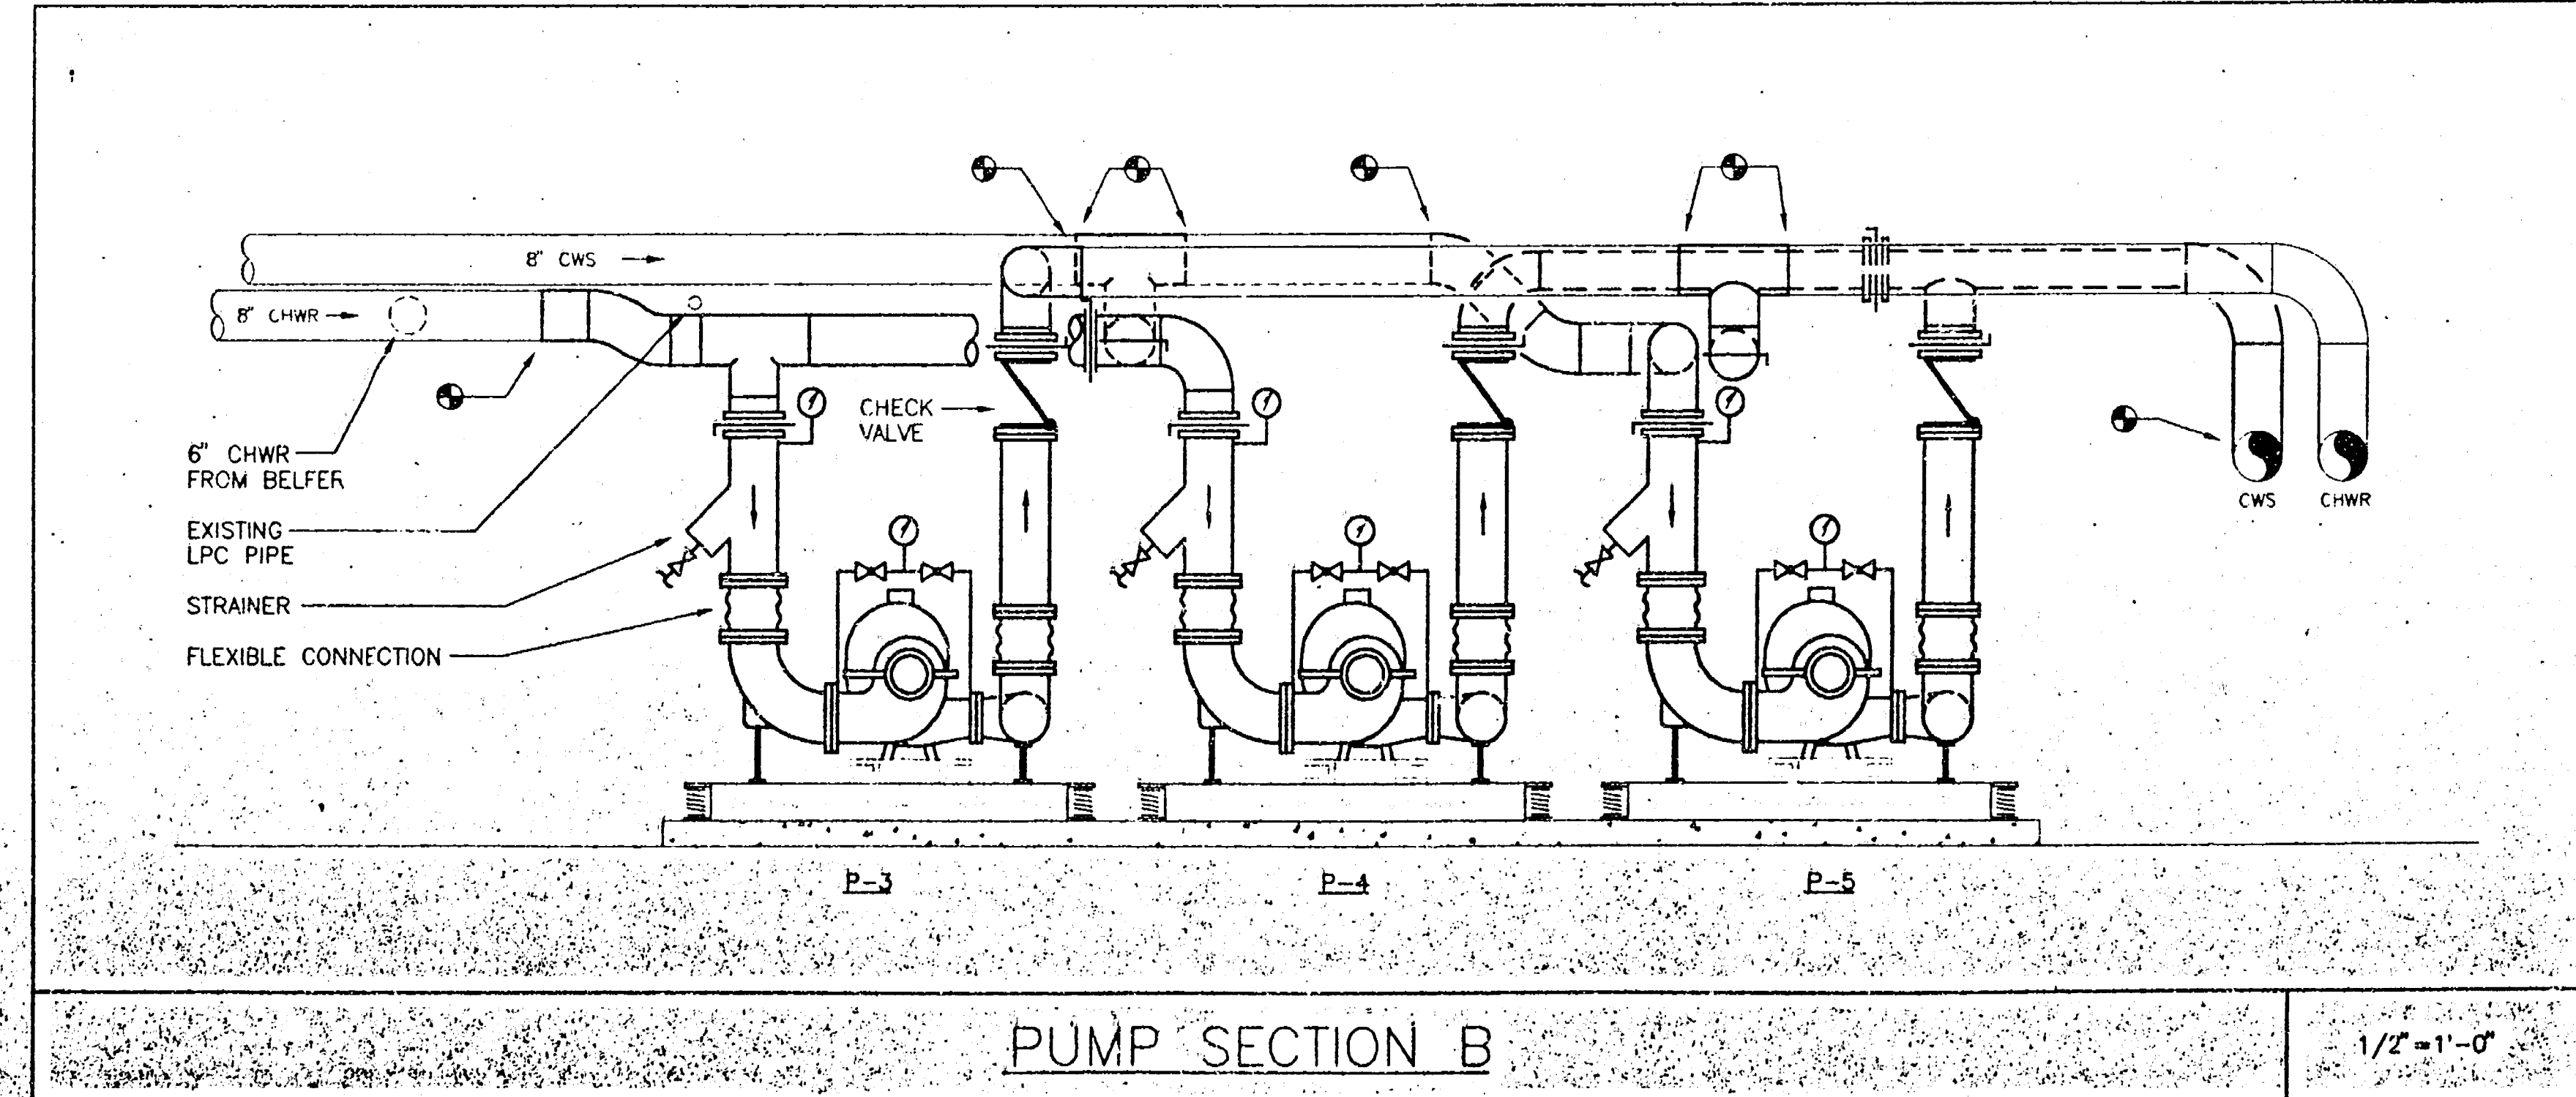

PUMP SECTION B
1/2"=1'-0"

NOTE:
ALL PIPING SHOWN IS 8"
UNLESS OTHERWISE NOTED.

GENERAL NOTES

NUMBER	REVISION	DATE

Engineered Solutions Inc.
74 Crescent Road, Norwalk, MA 02551 607-449-7250 Fax 407-7200

THE JFK SCHOOL OF GOVERNMENT HARVARD UNIVERSITY CHILLER PLANT RENOVATION LITTAUER CENTER/BELFER ADDITION

Drawing Title: **GROUND LEVEL MECHANICAL ROOM HVAC**

SCALE: AS SHOWN DRAWN BY: JMF

DATE: 18 DEC 94 CHECKED BY: GD

REVIEWED BY: ED

DRAWING NAME: **M1**