

BELFER CENTER
KENNEDY SCHOOL of
GOVERNMENT
HARVARD
UNIVERSITY

SCALE: 1/4"=1'-0"
DRAWN: RZM
DATE: 6/15/83
REV: 9/21/83

SECOND FLOOR
REFLECTED CEILING
PLAN



ARCHITECT
ARCHITECTURAL
RESOURCES
CAMBRIDGE, INC.

GILBANE
BUILDING CO.
GENERAL
CONTRACTORS

SUBMITTED BY
MOREDMALLO
129 SECOND ST
MANCHESTER
NEW HAMPSHIRE

NO. 20015
DATED: 4-11-81



DATE: 11-23-83

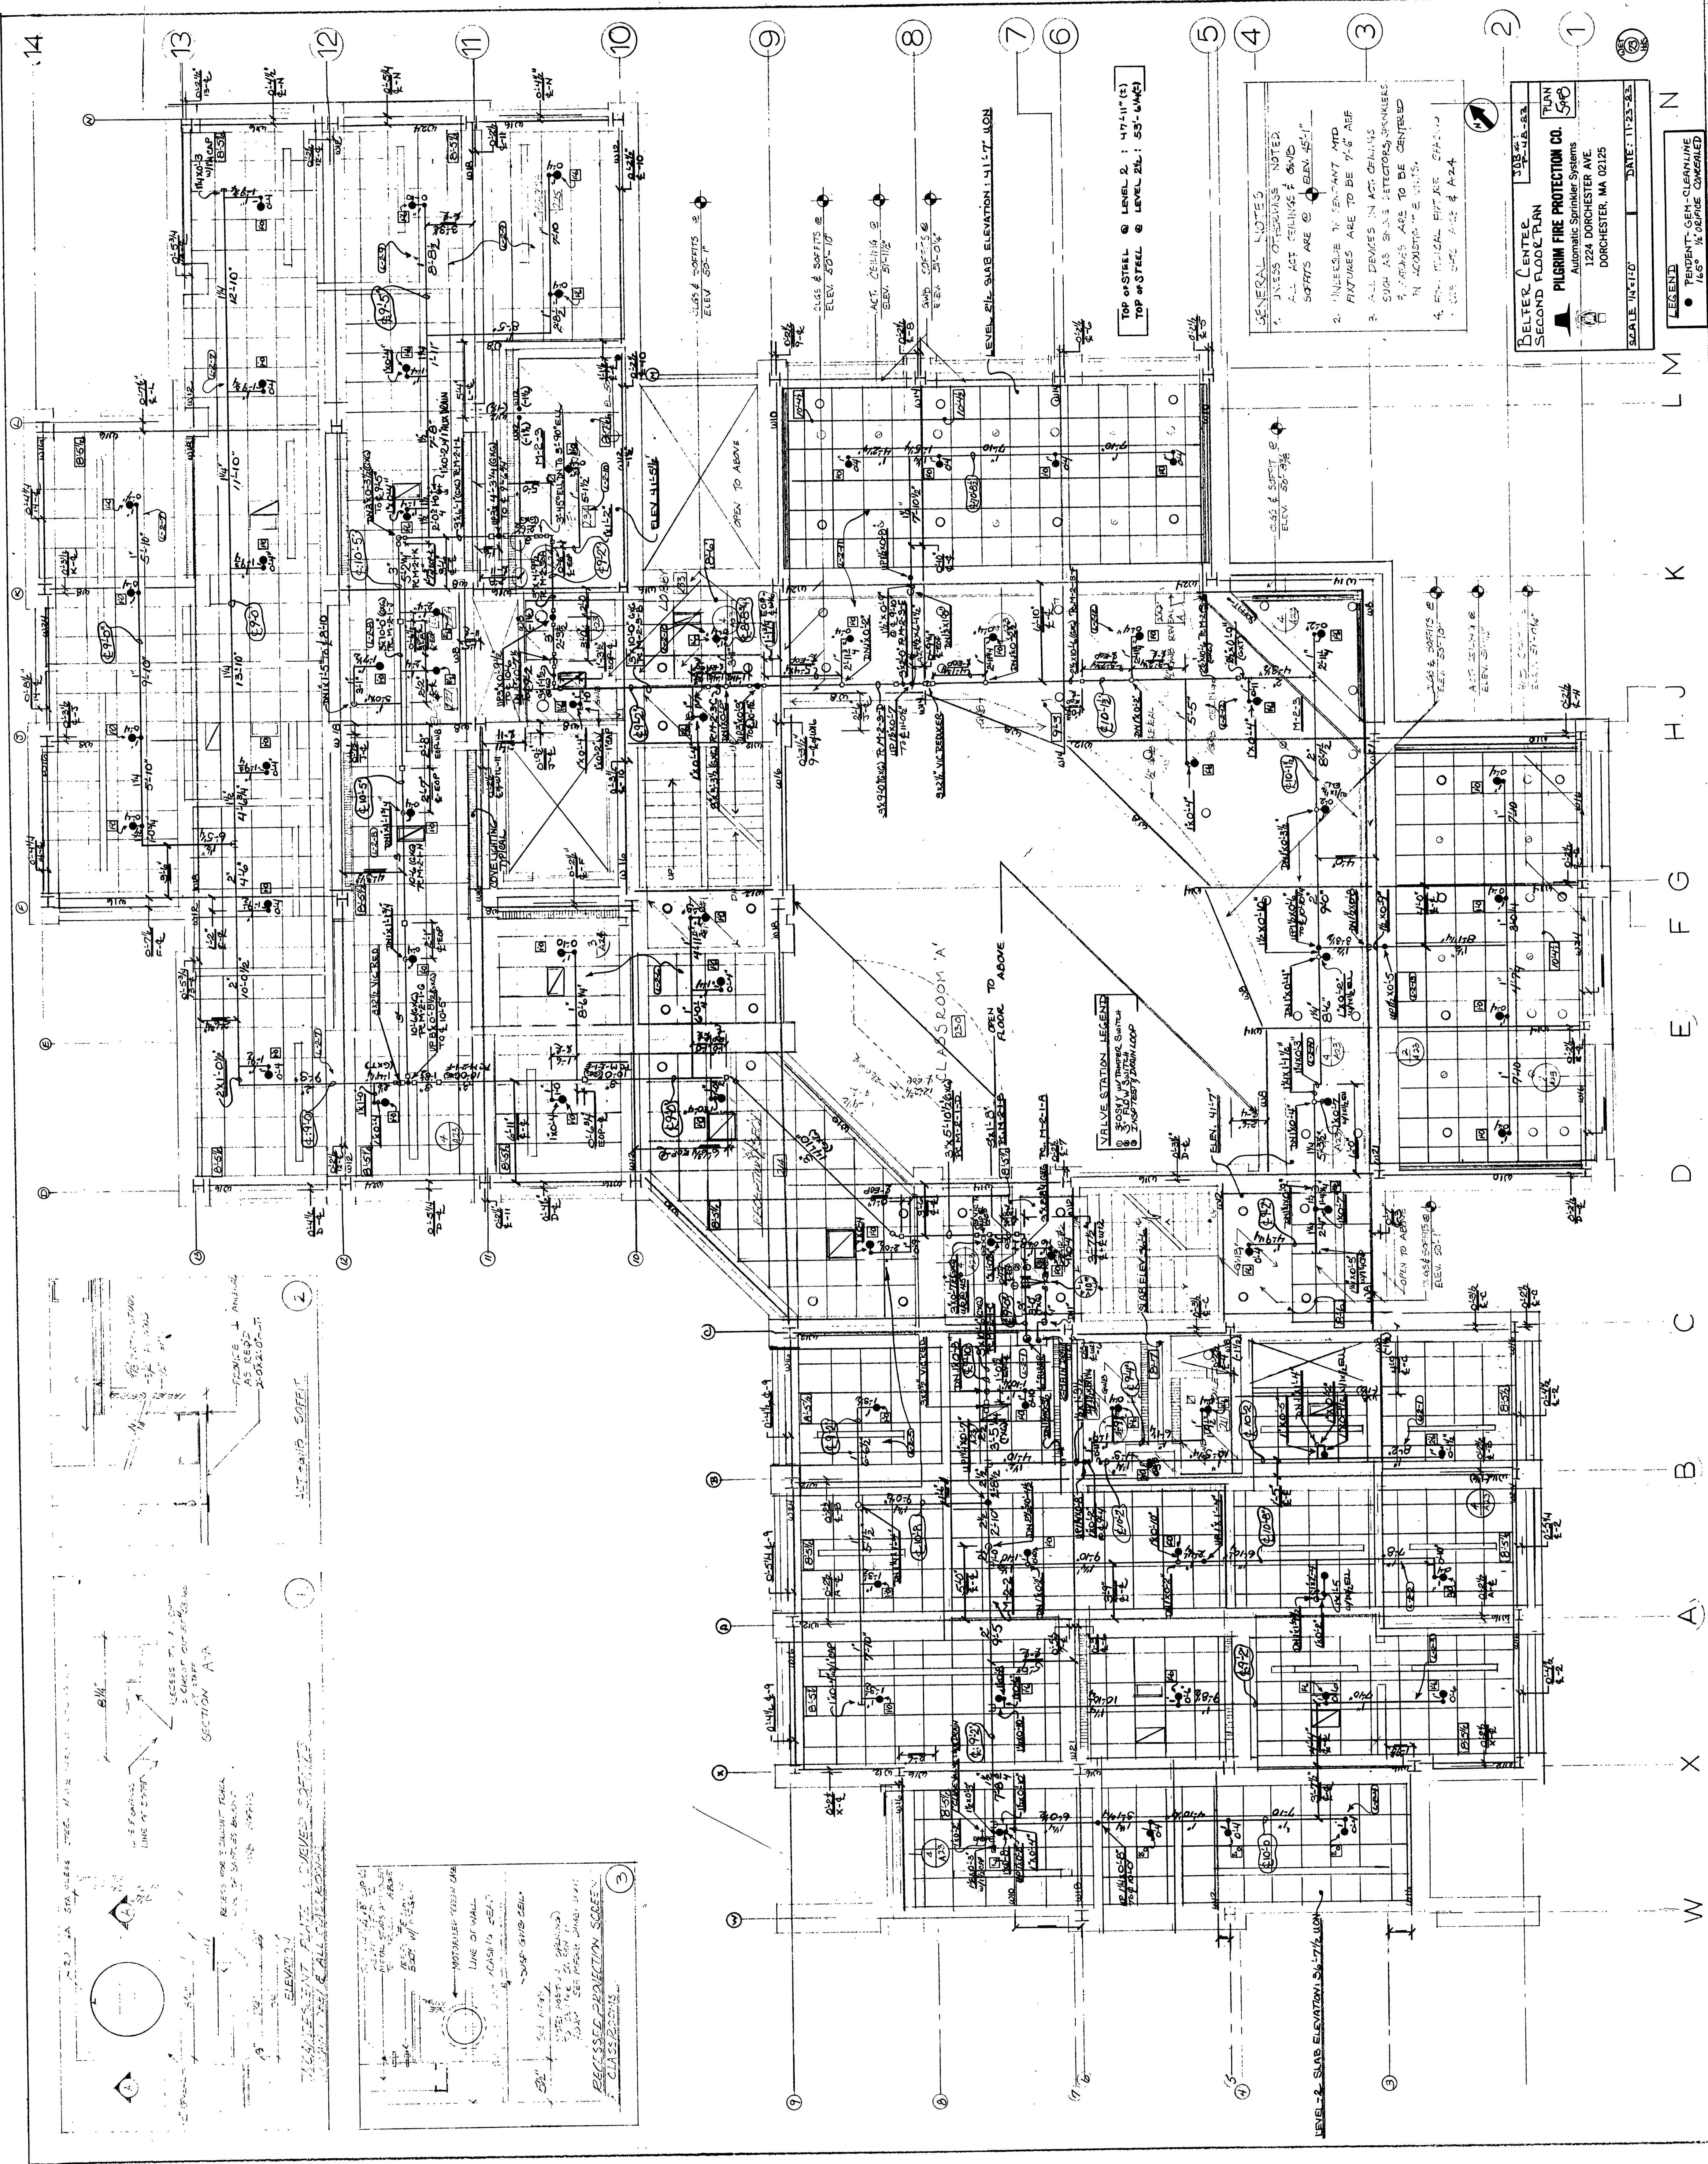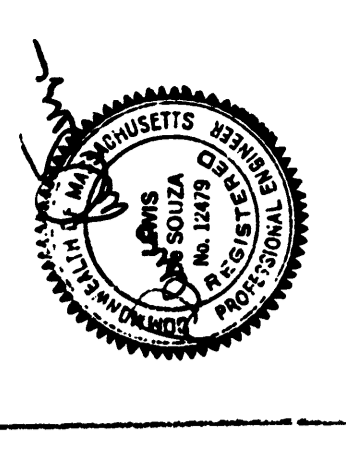

GENERAL NOTES
1. UNLESS OTHERWISE NOTED, ALL ACT. CEILING & SOFFIT FIXTURES ARE TO BE 7'-6" AFF. SOFFITS ARE @ ELEV. 45'-11"
2. INCLUDE IN TENANT AND FIXTURES ARE TO BE 7'-6" AFF. SUCH AS SMOKE DETECTORS, SPRINKLES & PROBES ARE TO BE CENTERED IN ROOMS.
3. FOR ALL ROOMS, AFF. ARE 7'-6" AFF. UNLESS OTHERWISE NOTED.

BELFER CENTER
SECOND FLOOR PLAN
PILRIM FIRE PROTECTION CO.
Automatic Sprinkler Systems
1224 DORCHESTER AVE.
DORCHESTER, MA 02125
SCALE: 1/4"=1'-0" DATE: 11-23-83

LEGEND
● PENDENT-GEN-CLEANLINE
○ 1/4" GEN-CLEANLINE

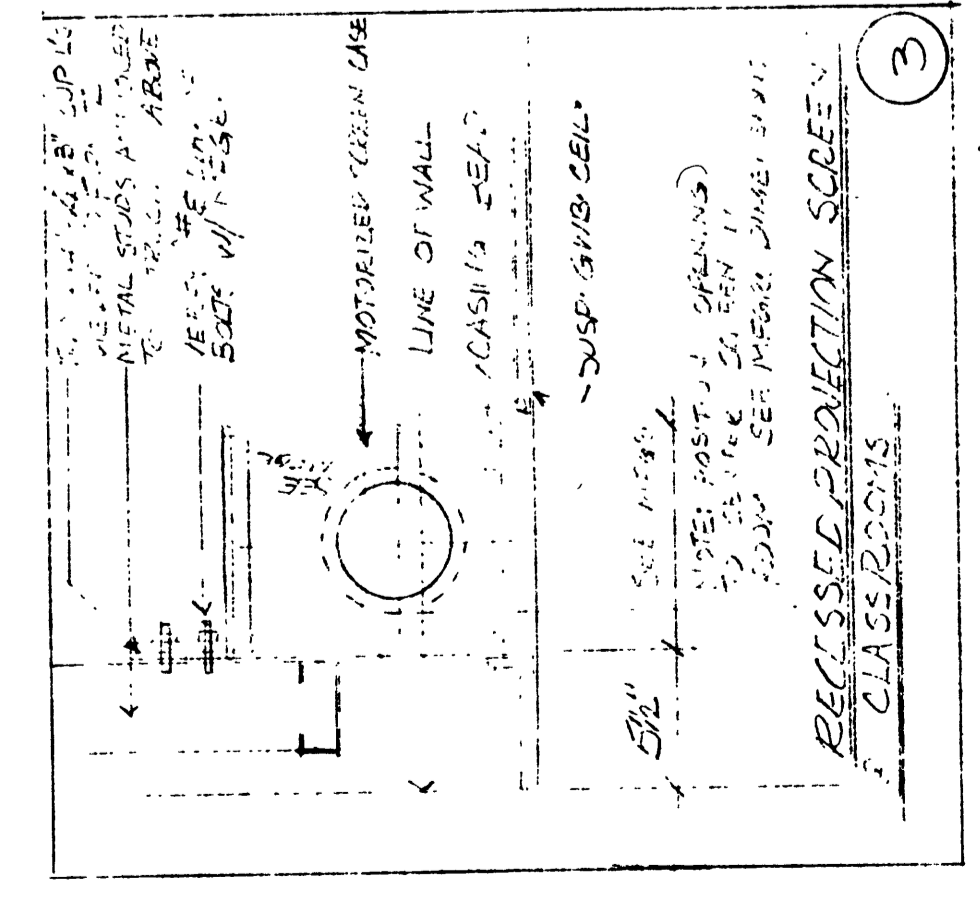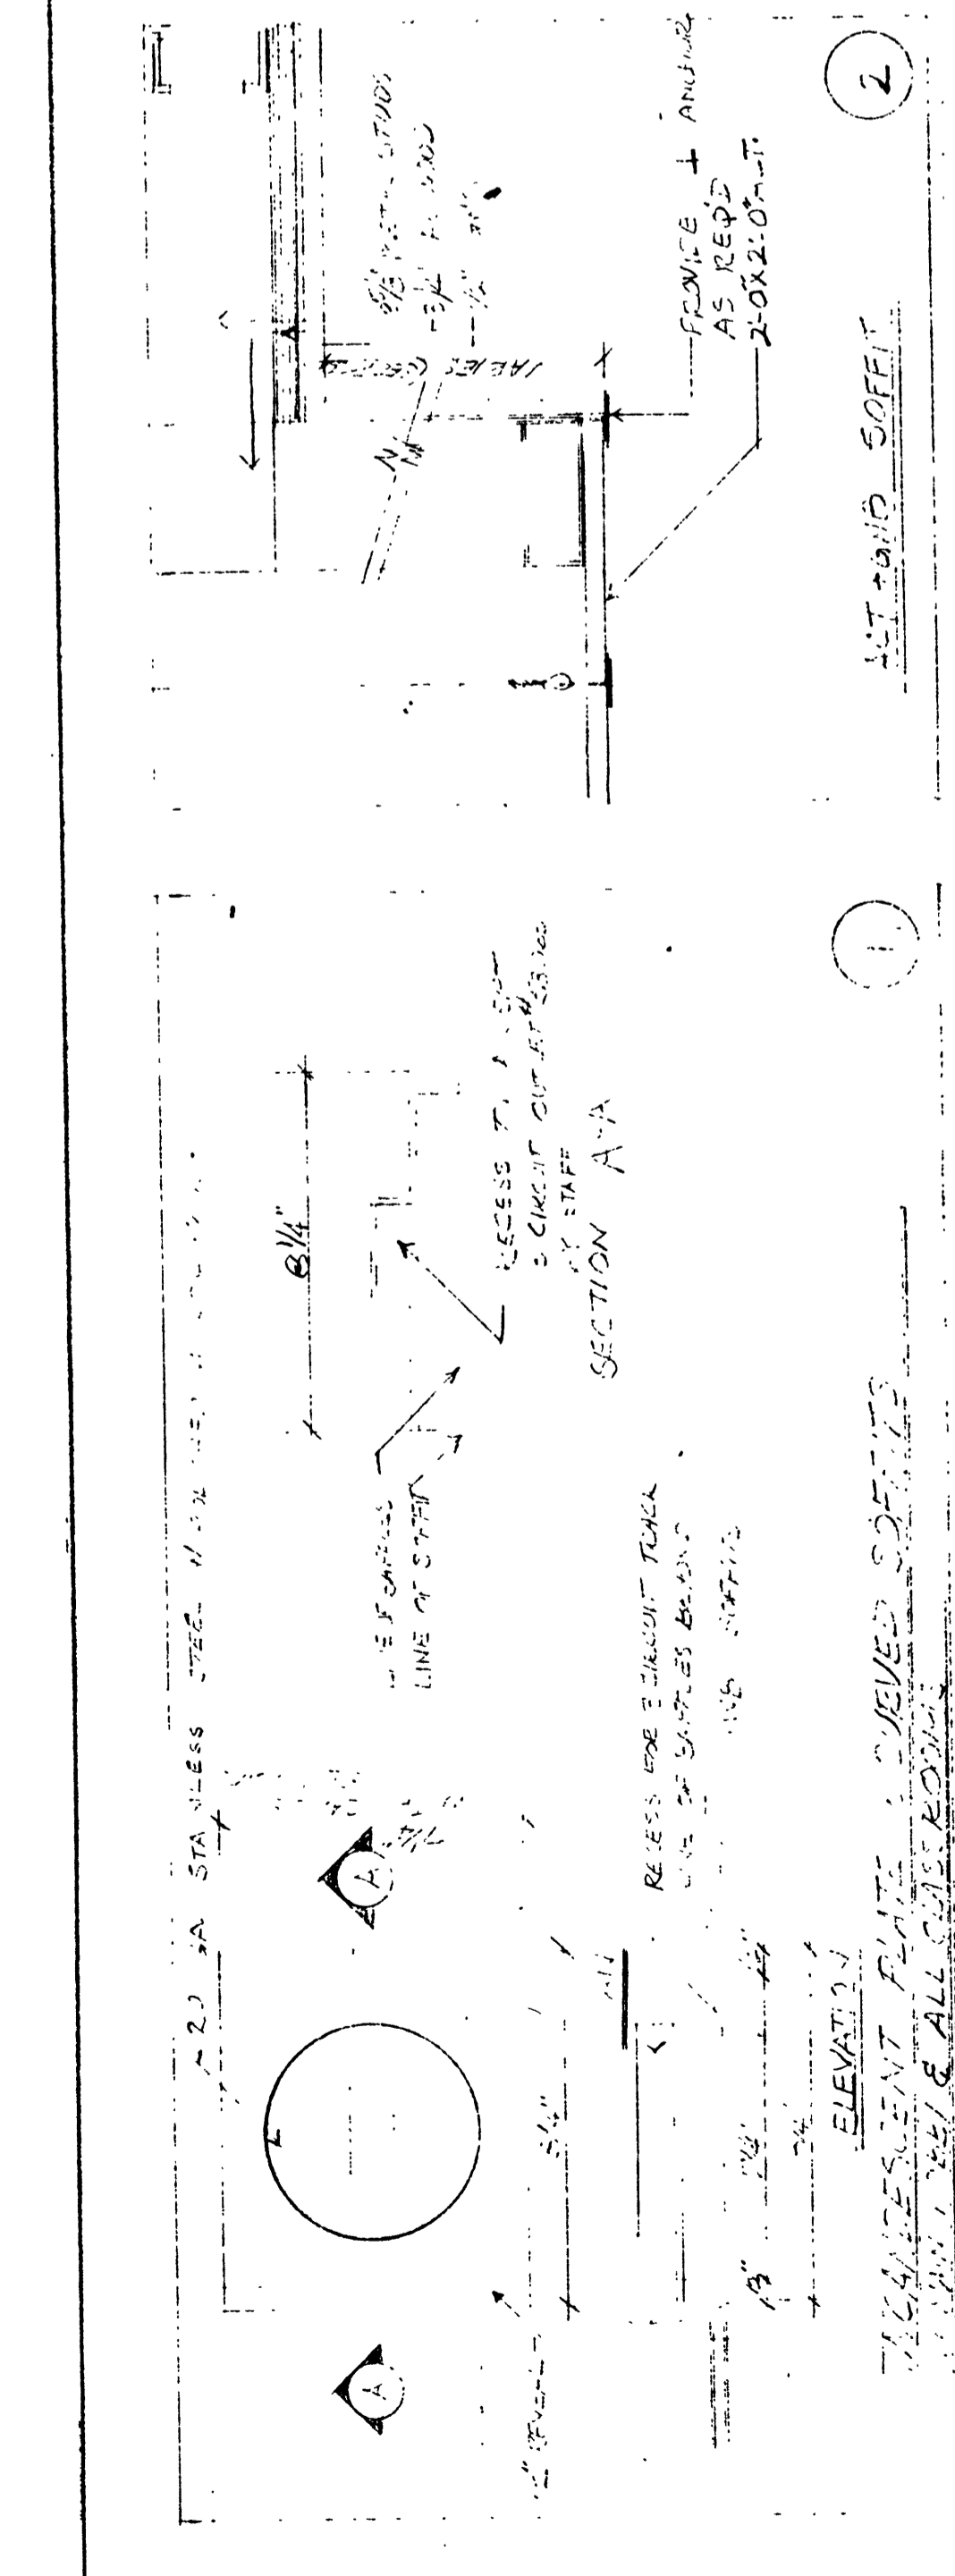

VALVE STATION LEGEND
○ FRESH AIR INTAKE VALVE
○ FRESH AIR INTAKE VALVE
○ FRESH AIR INTAKE VALVE

TOP OF STEEL @ LEVEL 2: 47'-11" (C)
TOP OF STEEL @ LEVEL 2L: 53'-0" (C)

LEVEL 2L SLAB ELEVATION: 41'-7" (N)

LEVEL 2L SLAB ELEVATION: 56'-7" (N)

CLASS & SOFFITS @ ELEV. 50'-11"

ACT. CEILING @ ELEV. 50'-11"

SOFFIT @ ELEV. 45'-11"

CLASS & SOFFIT @ ELEV. 50'-11"

ACT. CEILING @ ELEV. 50'-11"

SOFFIT @ ELEV. 45'-11"

CLASS & SOFFIT @ ELEV. 50'-11"

ACT. CEILING @ ELEV. 50'-11"

SOFFIT @ ELEV. 45'-11"

CLASS & SOFFIT @ ELEV. 50'-11"

ACT. CEILING @ ELEV. 50'-11"

SOFFIT @ ELEV. 45'-11"

CLASS & SOFFIT @ ELEV. 50'-11"

ACT. CEILING @ ELEV. 50'-11"

SOFFIT @ ELEV. 45'-11"