

BELFEL CENTER  
KENNEDY SCHOOL OF  
GOVERNMENT  
HARVARD UNIVERSITY.

SCALE: 1/4"=1'-0"  
DRAWN RCM  
DATE: 6/15/83  
REF: 9/20/83

THIRD FLOOR  
REFLECTED CEILING  
PLAN


ARCHITECT:  
ARCHITECTURAL  
RESOURCES  
CAMBRIDGE  
INC.

GILBANE  
BUILDING CO.  
GENERAL  
CONTRACTORS.


SUBMITTED BY:  
MORE DRIVALLCO.  
129 SECOND ST.  
MANCHESTER  
NEW HAMPSHIRE

DATE: 6/15/83  
REF: 9/20/83

AS BUILT  
DATE: 11-23-83

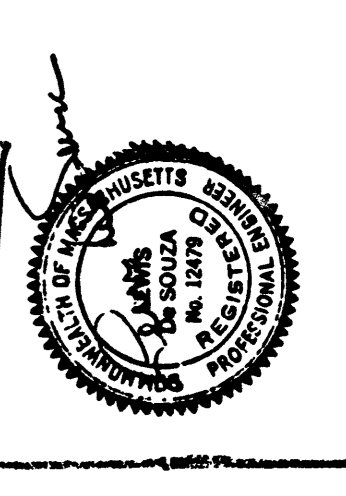


107-0082

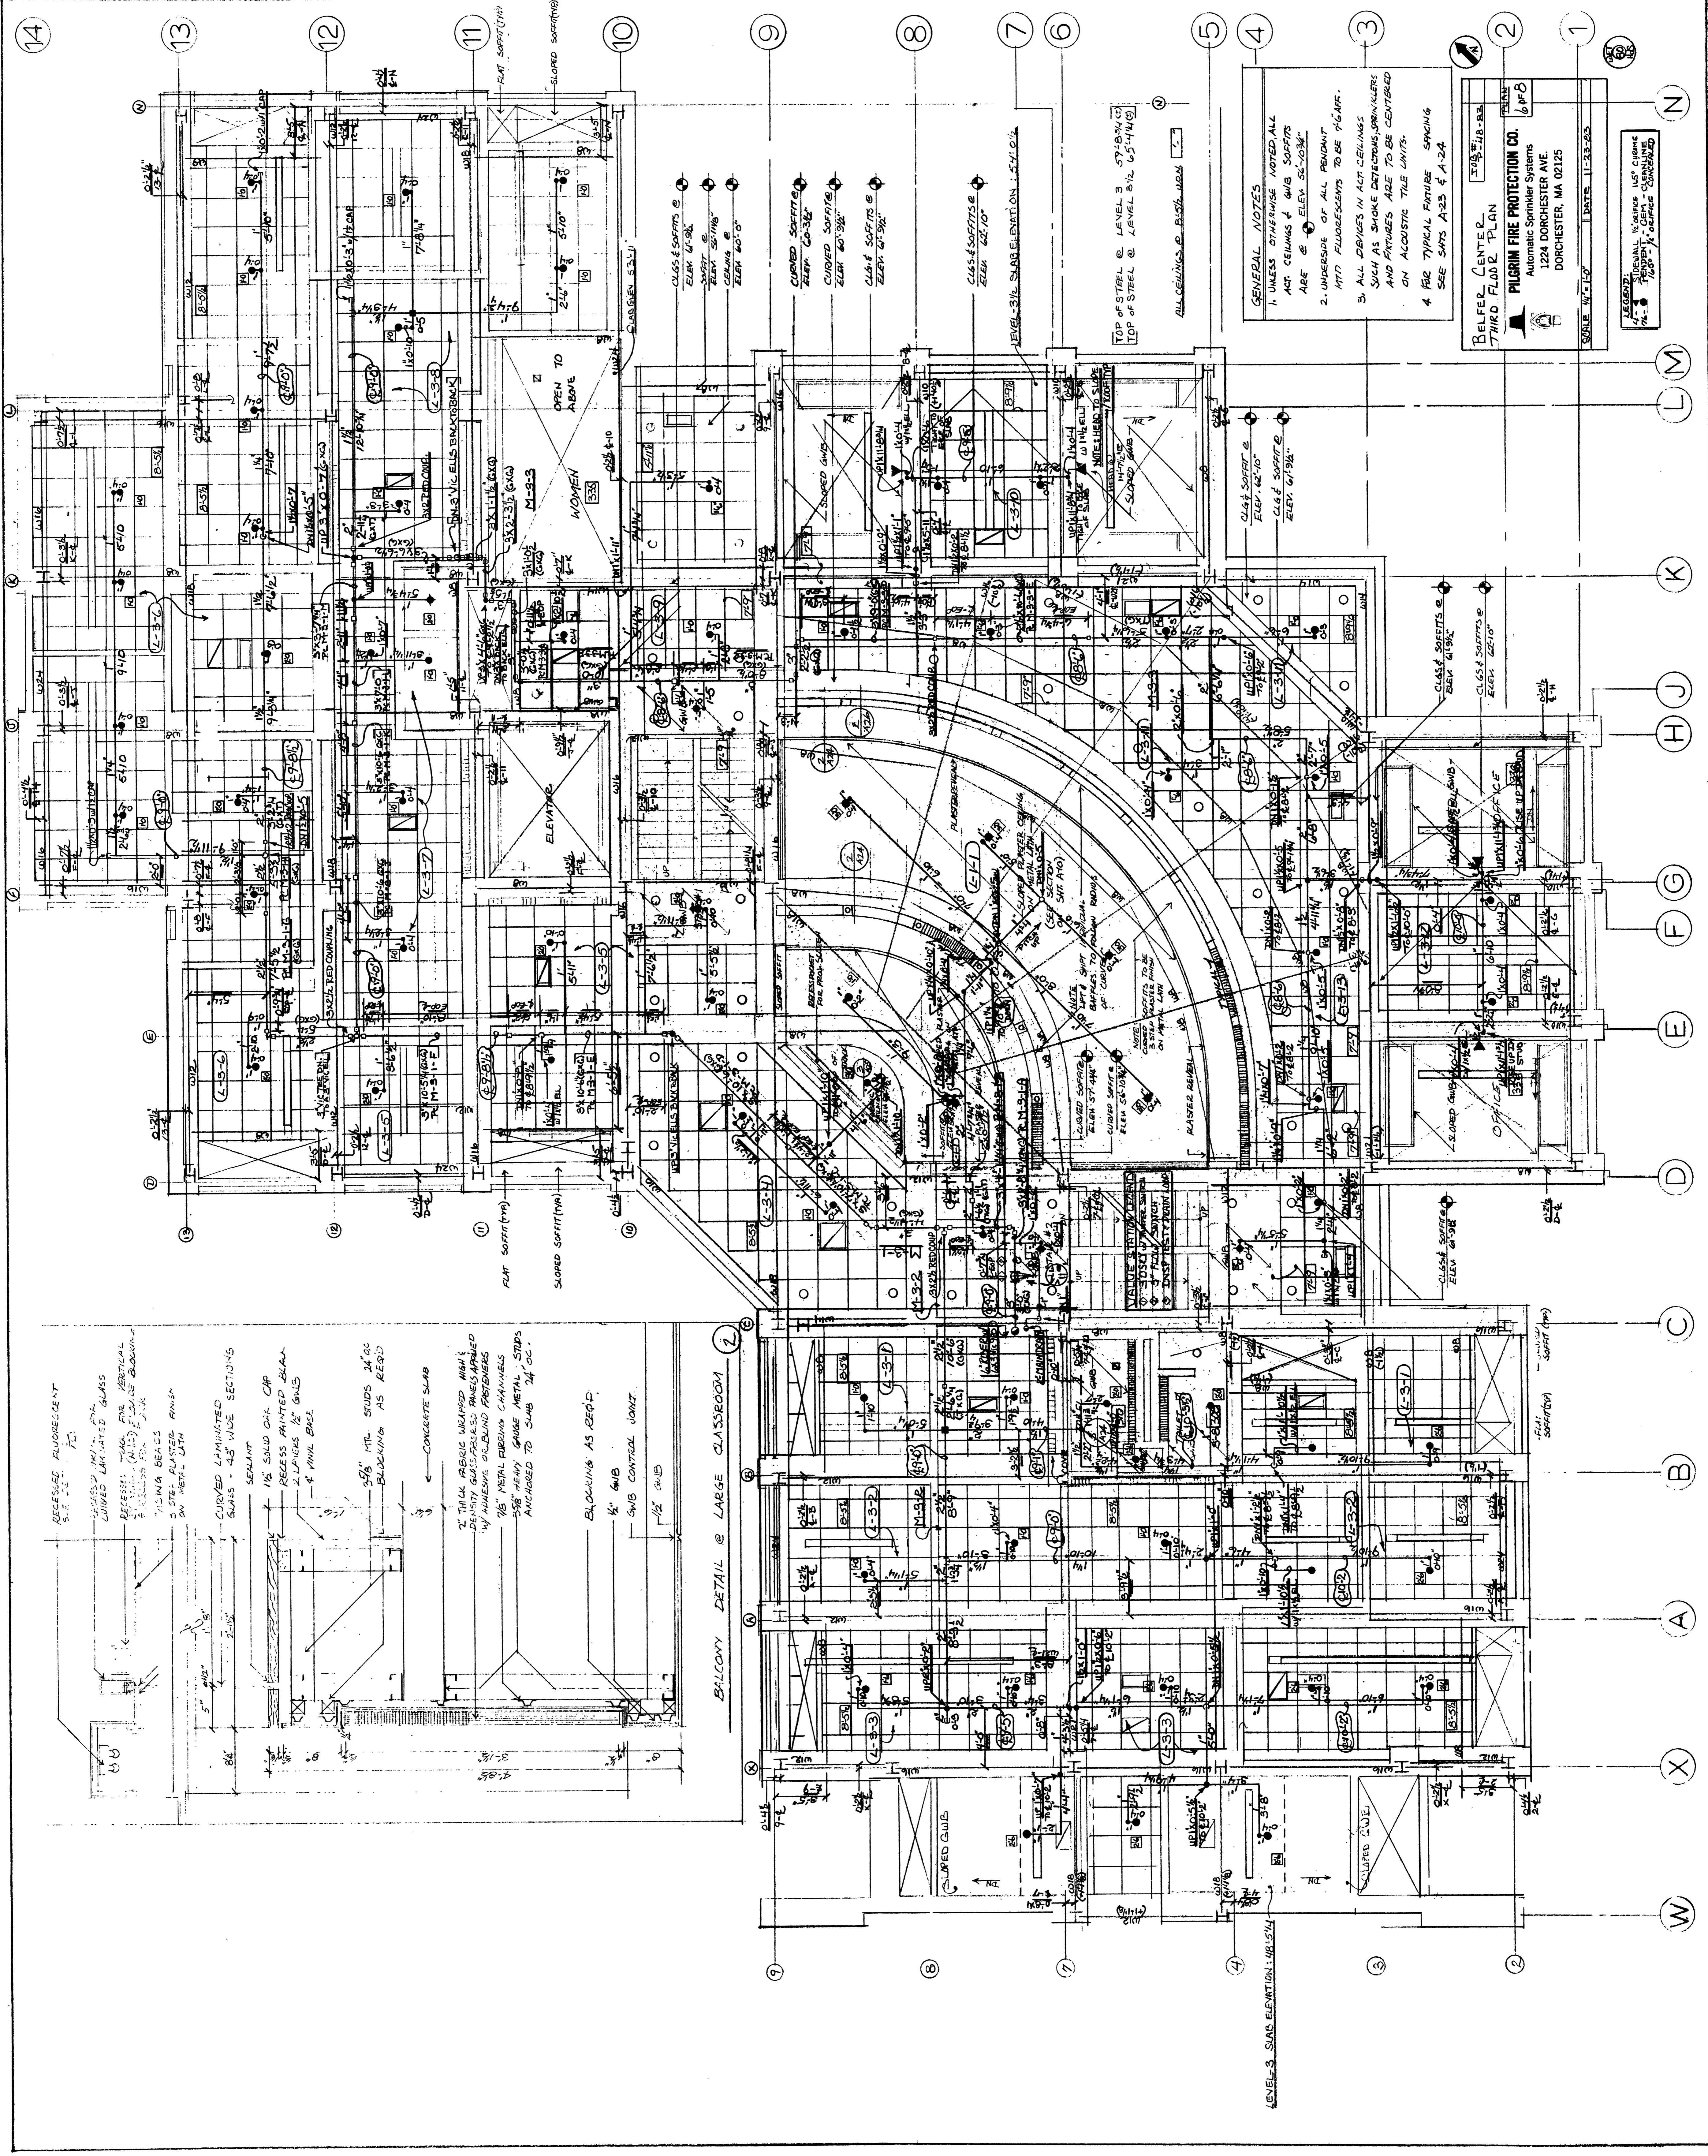

**GENERAL NOTES**  
1. UNLESS OTHERWISE NOTED ALL ACT. CEILING & GNB SOFFITS ARE @ ELEV. 57'-0 3/4\"/>


**BELFEL CENTER  
THIRD FLOOR PLAN**  
DATE: 11-23-83  
**PILGRIM FIRE PROTECTION CO.**  
Automatic Sprinkler Systems  
1224 DORCHESTER AVE.  
DORCHESTER, MA 02125  
SCALE: 1/4"=1'-0" DATE: 11-23-83

**LEGEND:**  
1. STRUCTURAL WALLS  
2. PARTITION WALLS  
3. CEILING  
4. FLOOR

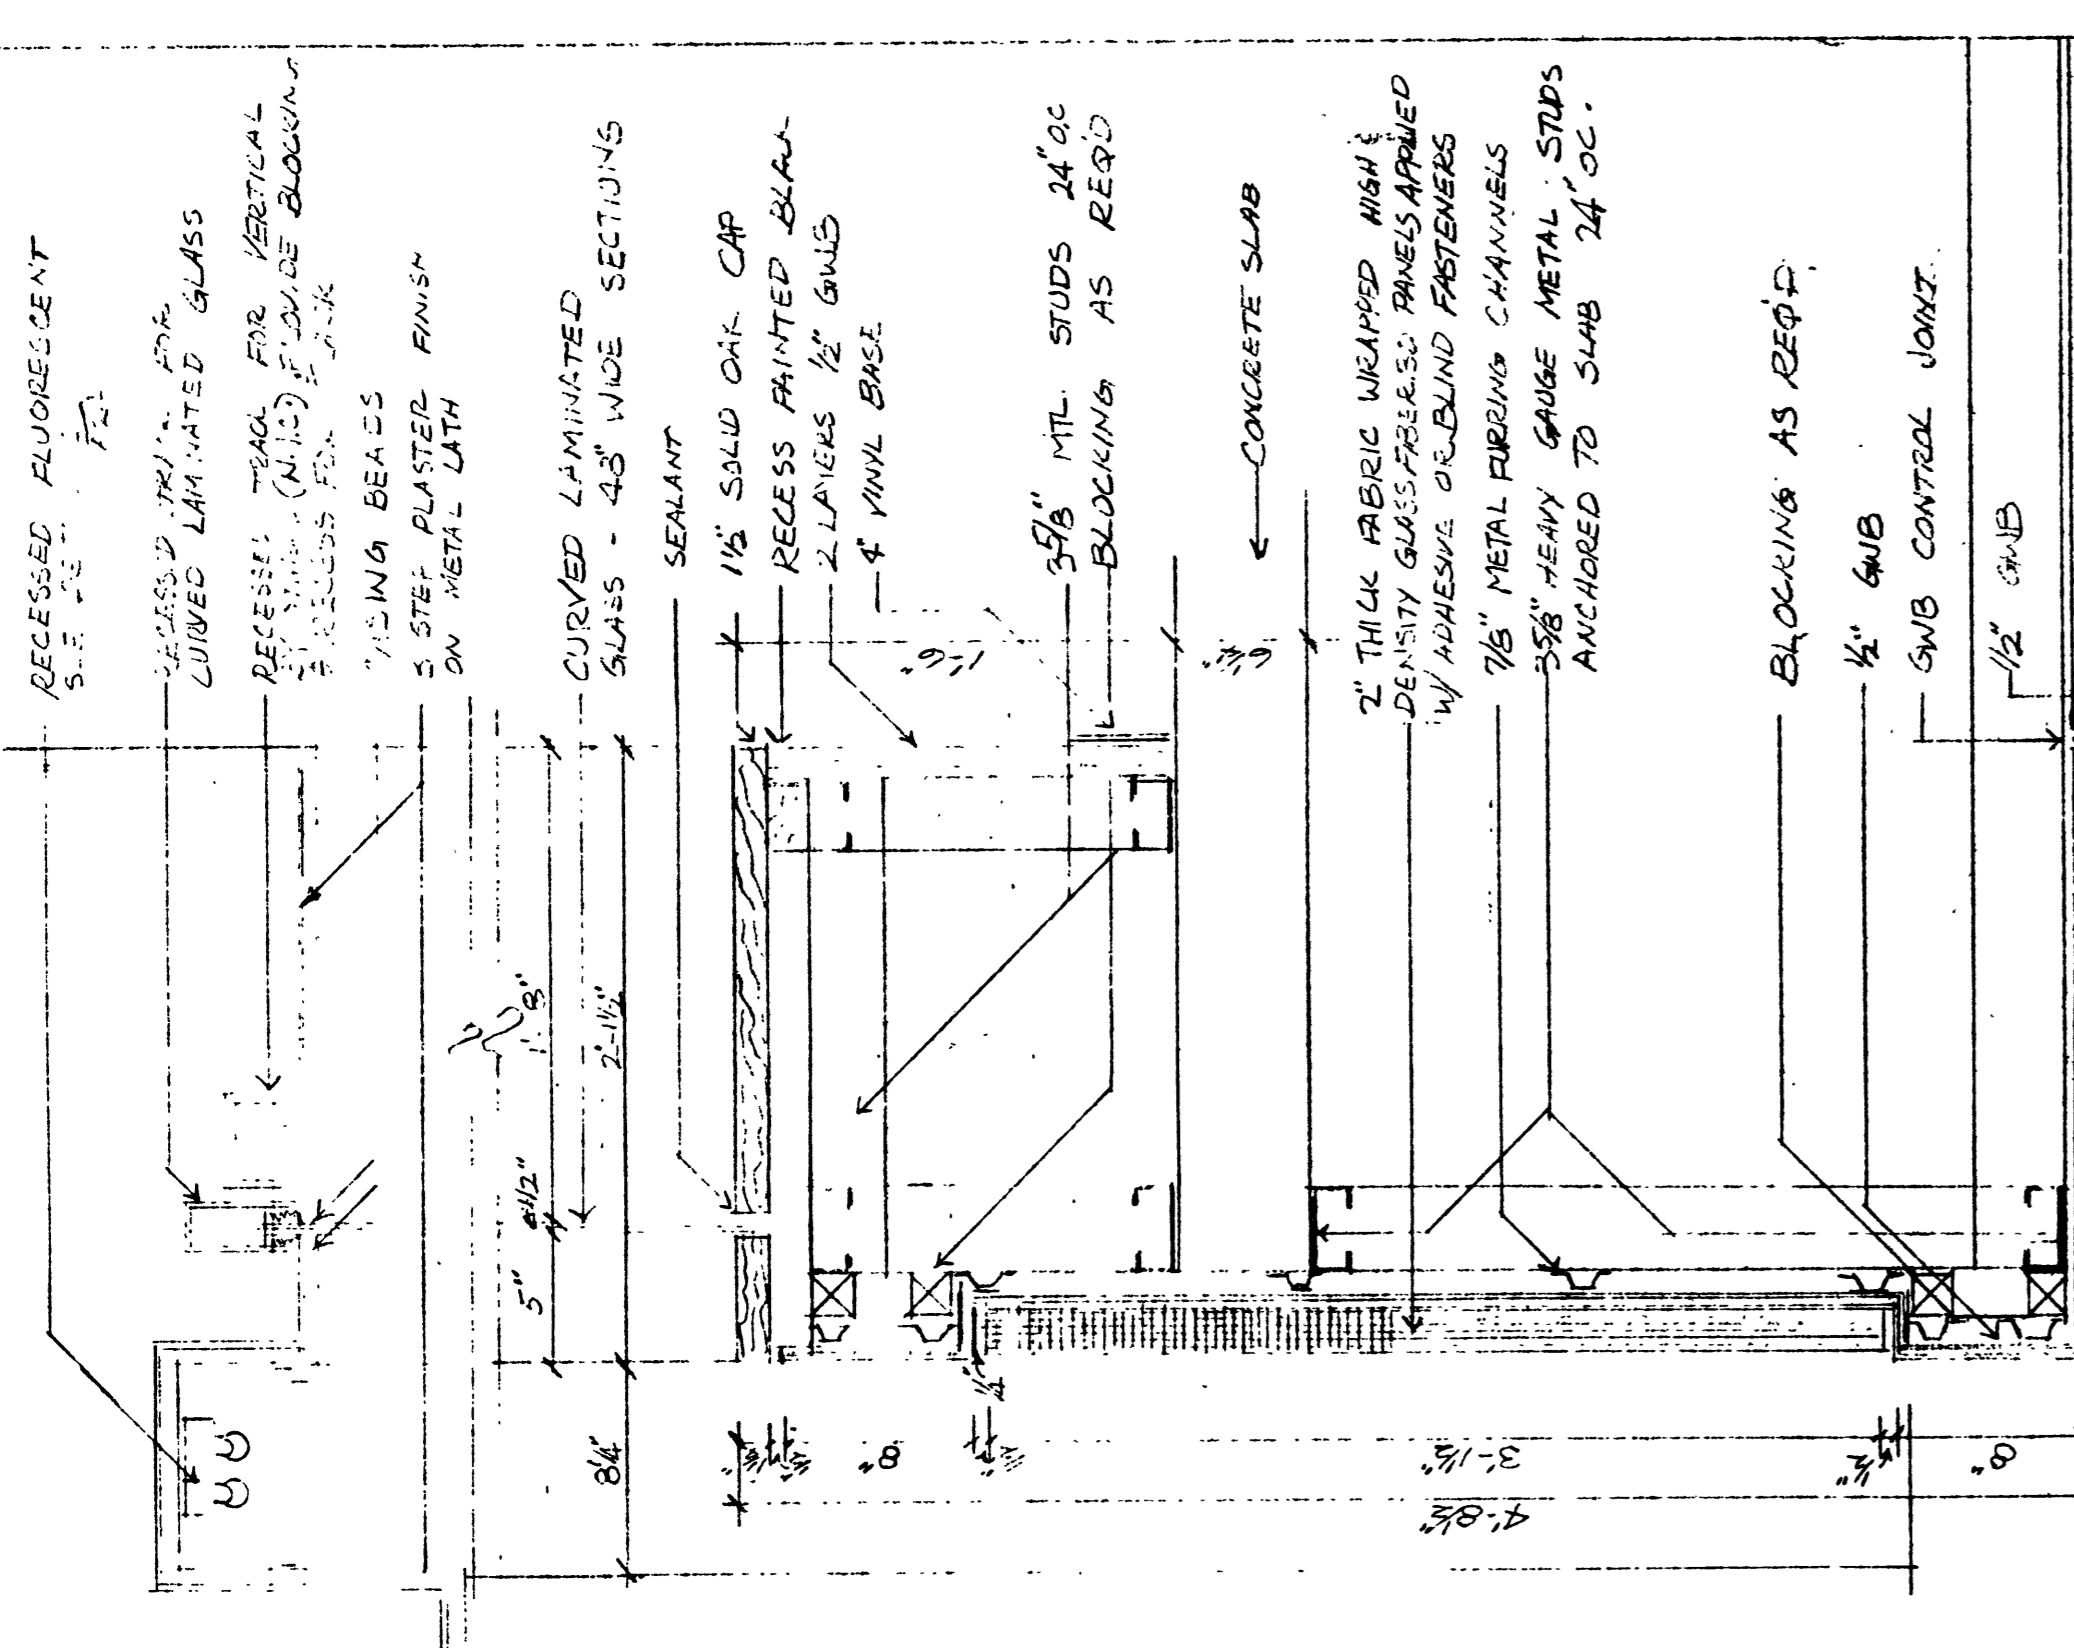

RECESSED ALUMINUM  
CLIMB LIMITED GLASS  
REFLECTED CEILING  
7/16\"/>

BALCONY DETAIL & LARGE CLASSROOM

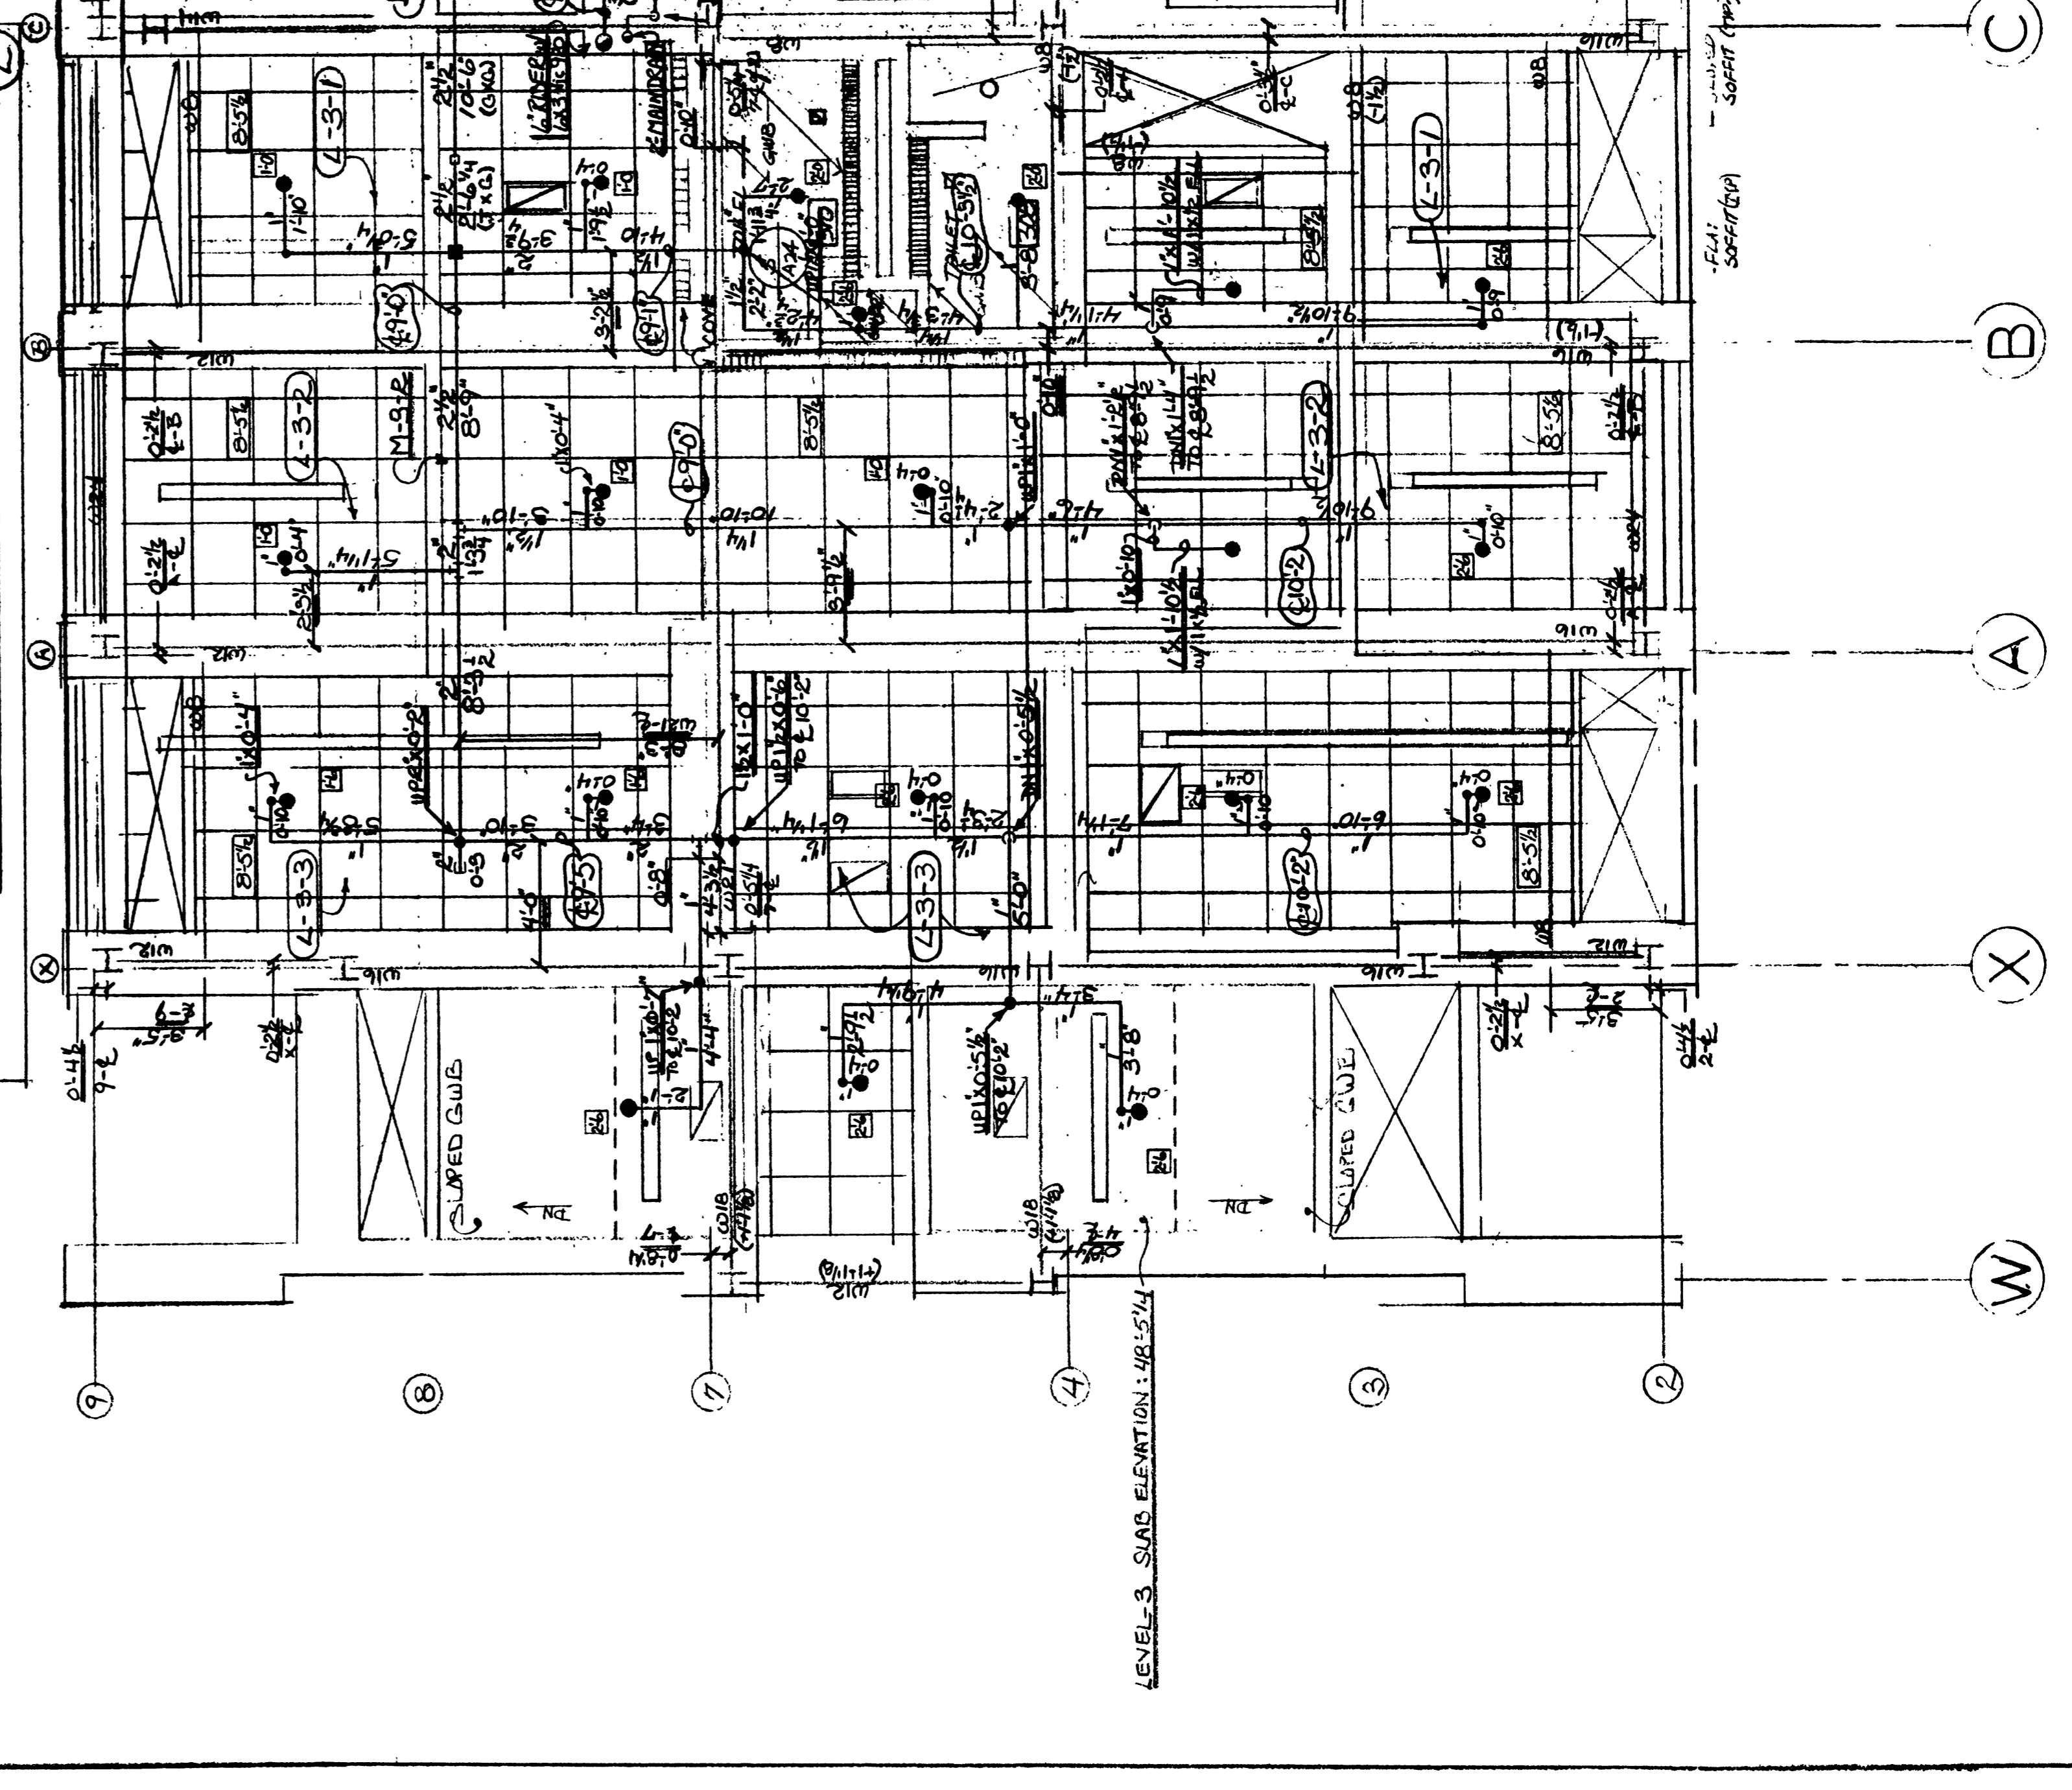

BALCONY DETAIL & LARGE CLASSROOM

50\"/>