

BELFER CENTER  
KENNEDY SCHOOL OF  
GOVERNMENT  
HARVARD UNIVERSITY

SCALE: 1/8"=1'-0"  
DRAWN: ECM  
DATE: 6/15/83  
REVISIONS:  
A  
A  
A

FOURTH FLOOR  
REFLECTED CEILING  
PLAN


ARCHITECT  
ARCHITECTURAL  
RESOURCES  
CAMBRIDGE  
INC.

GILBANE  
BUILDINGS CO  
GENERAL  
CONTRACTORS


SUBMITTED BY:  
MORE DRYWALL  
CO. INC.  
129 SECOND ST  
MANCHESTER, NH

SCALE BAR  
0' 0" 3' 0" 6' 0" 9' 0" 12' 0"

AS-BUILTS  
DATED: 4-11-84

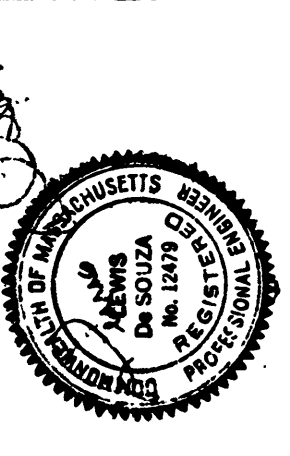

707-0089

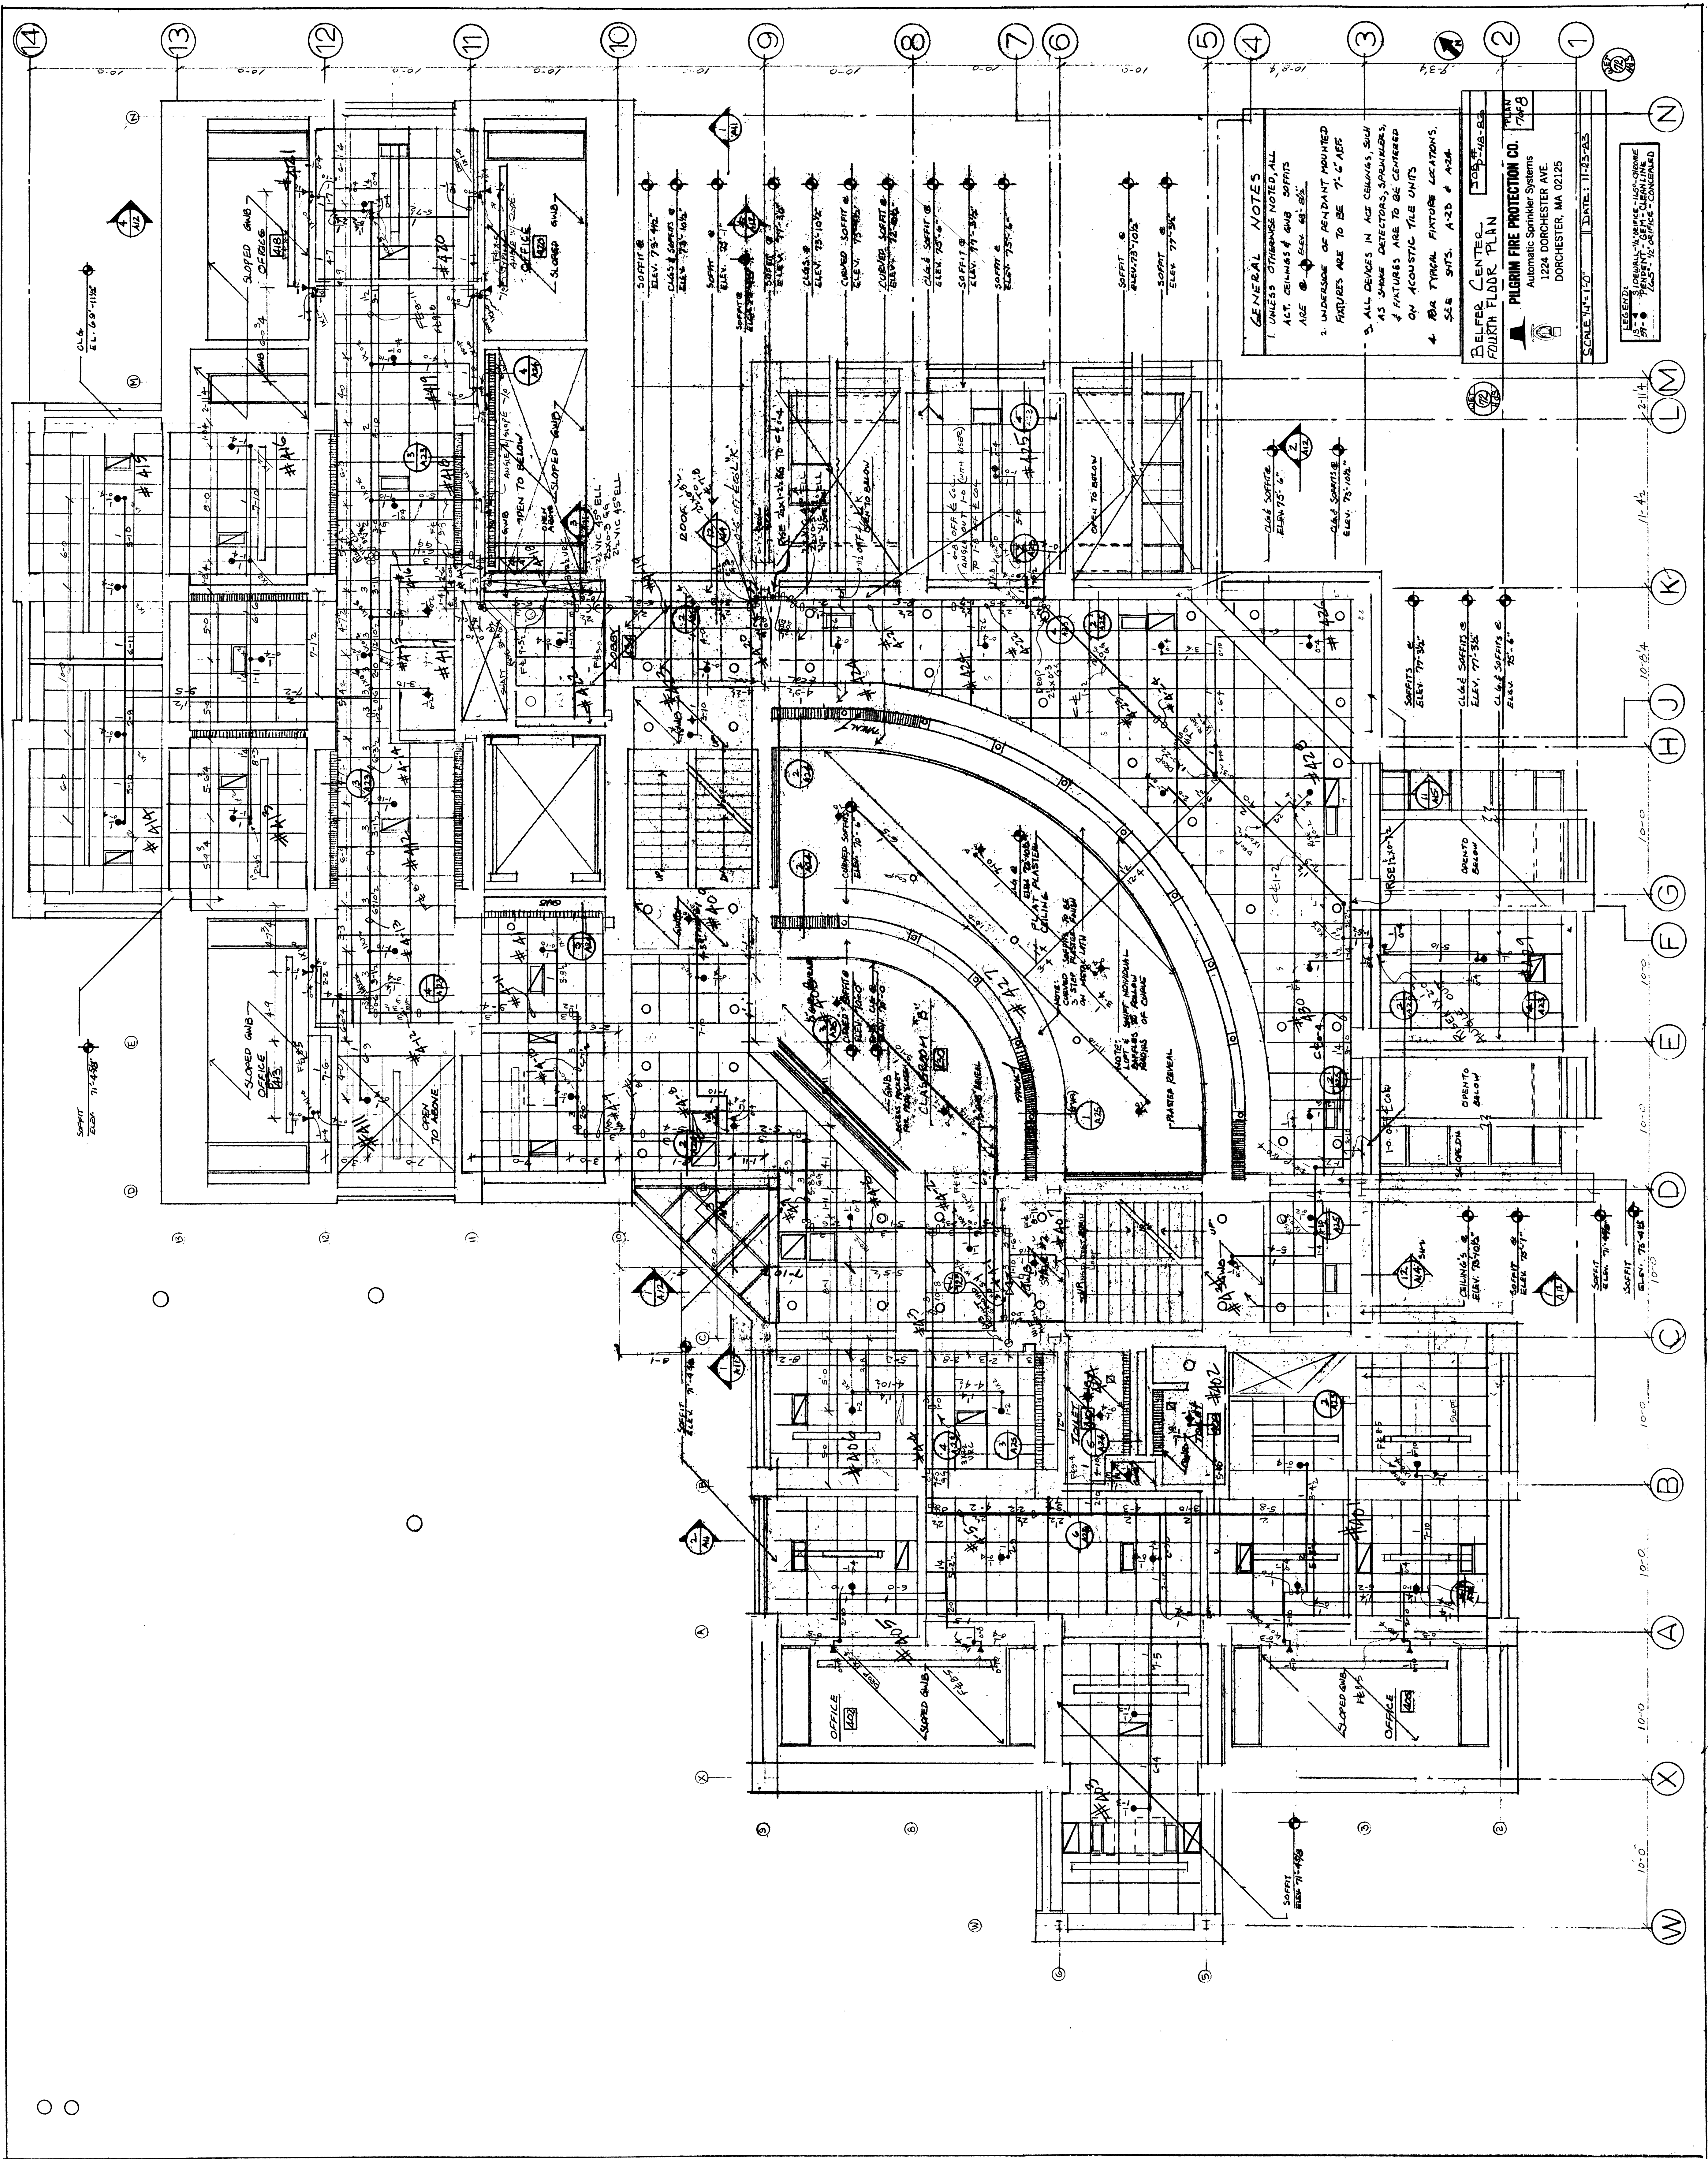

**GENERAL NOTES**  
1. UNLESS OTHERWISE NOTED, ALL ACT. CEILING & GIB SOFFITS ARE @ ELEV. 6'-0".  
2. UNDERSIDE OF PENDANT MOUNTED FIXTURES ARE TO BE 7'-0" AFF.  
3. ALL DEVICES IN ACT. CEILING SHALL AS SHOWN DETECTORS, SPRINKLERS & FIXTURES ARE TO BE CENTERED ON ACOUSTIC TILE UNITS.  
4. FOR TYPICAL FIXTURE LOCATIONS, SEE SHTS. A-23 & A-24.

BELFER CENTER  
FOURTH FLOOR PLAN  
DATE: 11-25-83

PIGMEER FIRE PROTECTION CO.  
Automatic Sprinkler Systems  
122A DORCHESTER AVE  
DORCHESTER, MA 02125

SCALE: 1/8"=1'-0" DATE: 11-25-83

LEGEND:  
1. ORIGINAL WORK - 1/8" LINE  
2. AS-BUILT WORK - 1/8" LINE  
3. WORK TO BE DONE - 1/8" LINE