
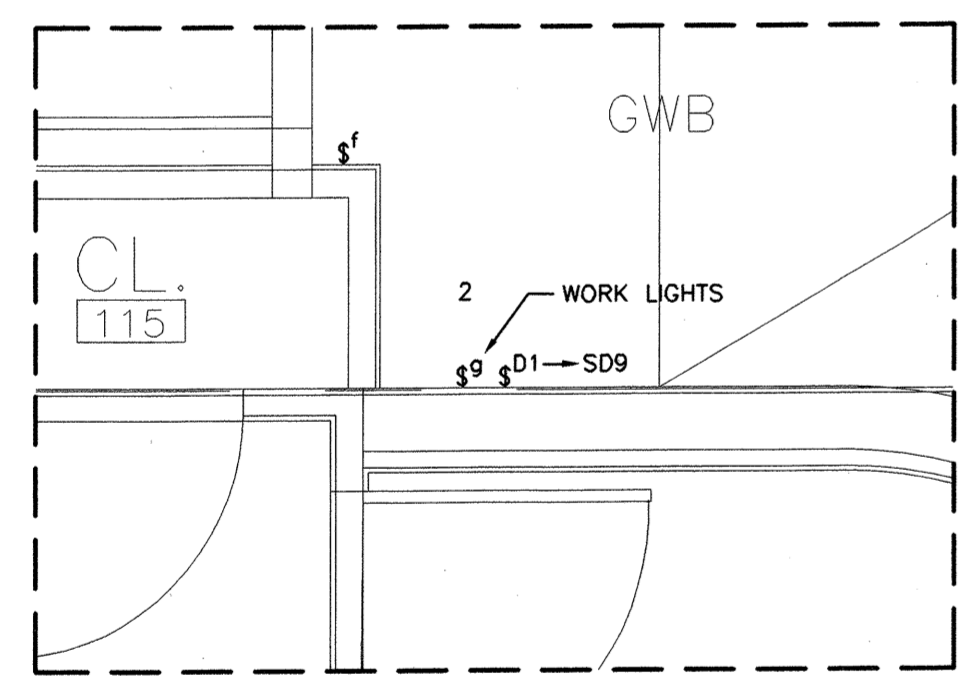


ALIED CONSULTANTS
 RICHMOND SO ENGINEERS
 SCHIRMER ENGINEERING
 COLLECTIVE WISDOM CORPORATION

A.R.T. BLACK BOX THEATRE AT 2-4 ARROW STREET, CAMBRIDGE MA
 HARVARD REAL ESTATE SERVICES / AMERICAN REPERTORY THEATRE

MARYANN THOMPSON ARCHITECTS
 14 HILLSIDE AVENUE
 CAMBRIDGE, MA 02140
 T. 617.461.4144
 F. 617.461.3844

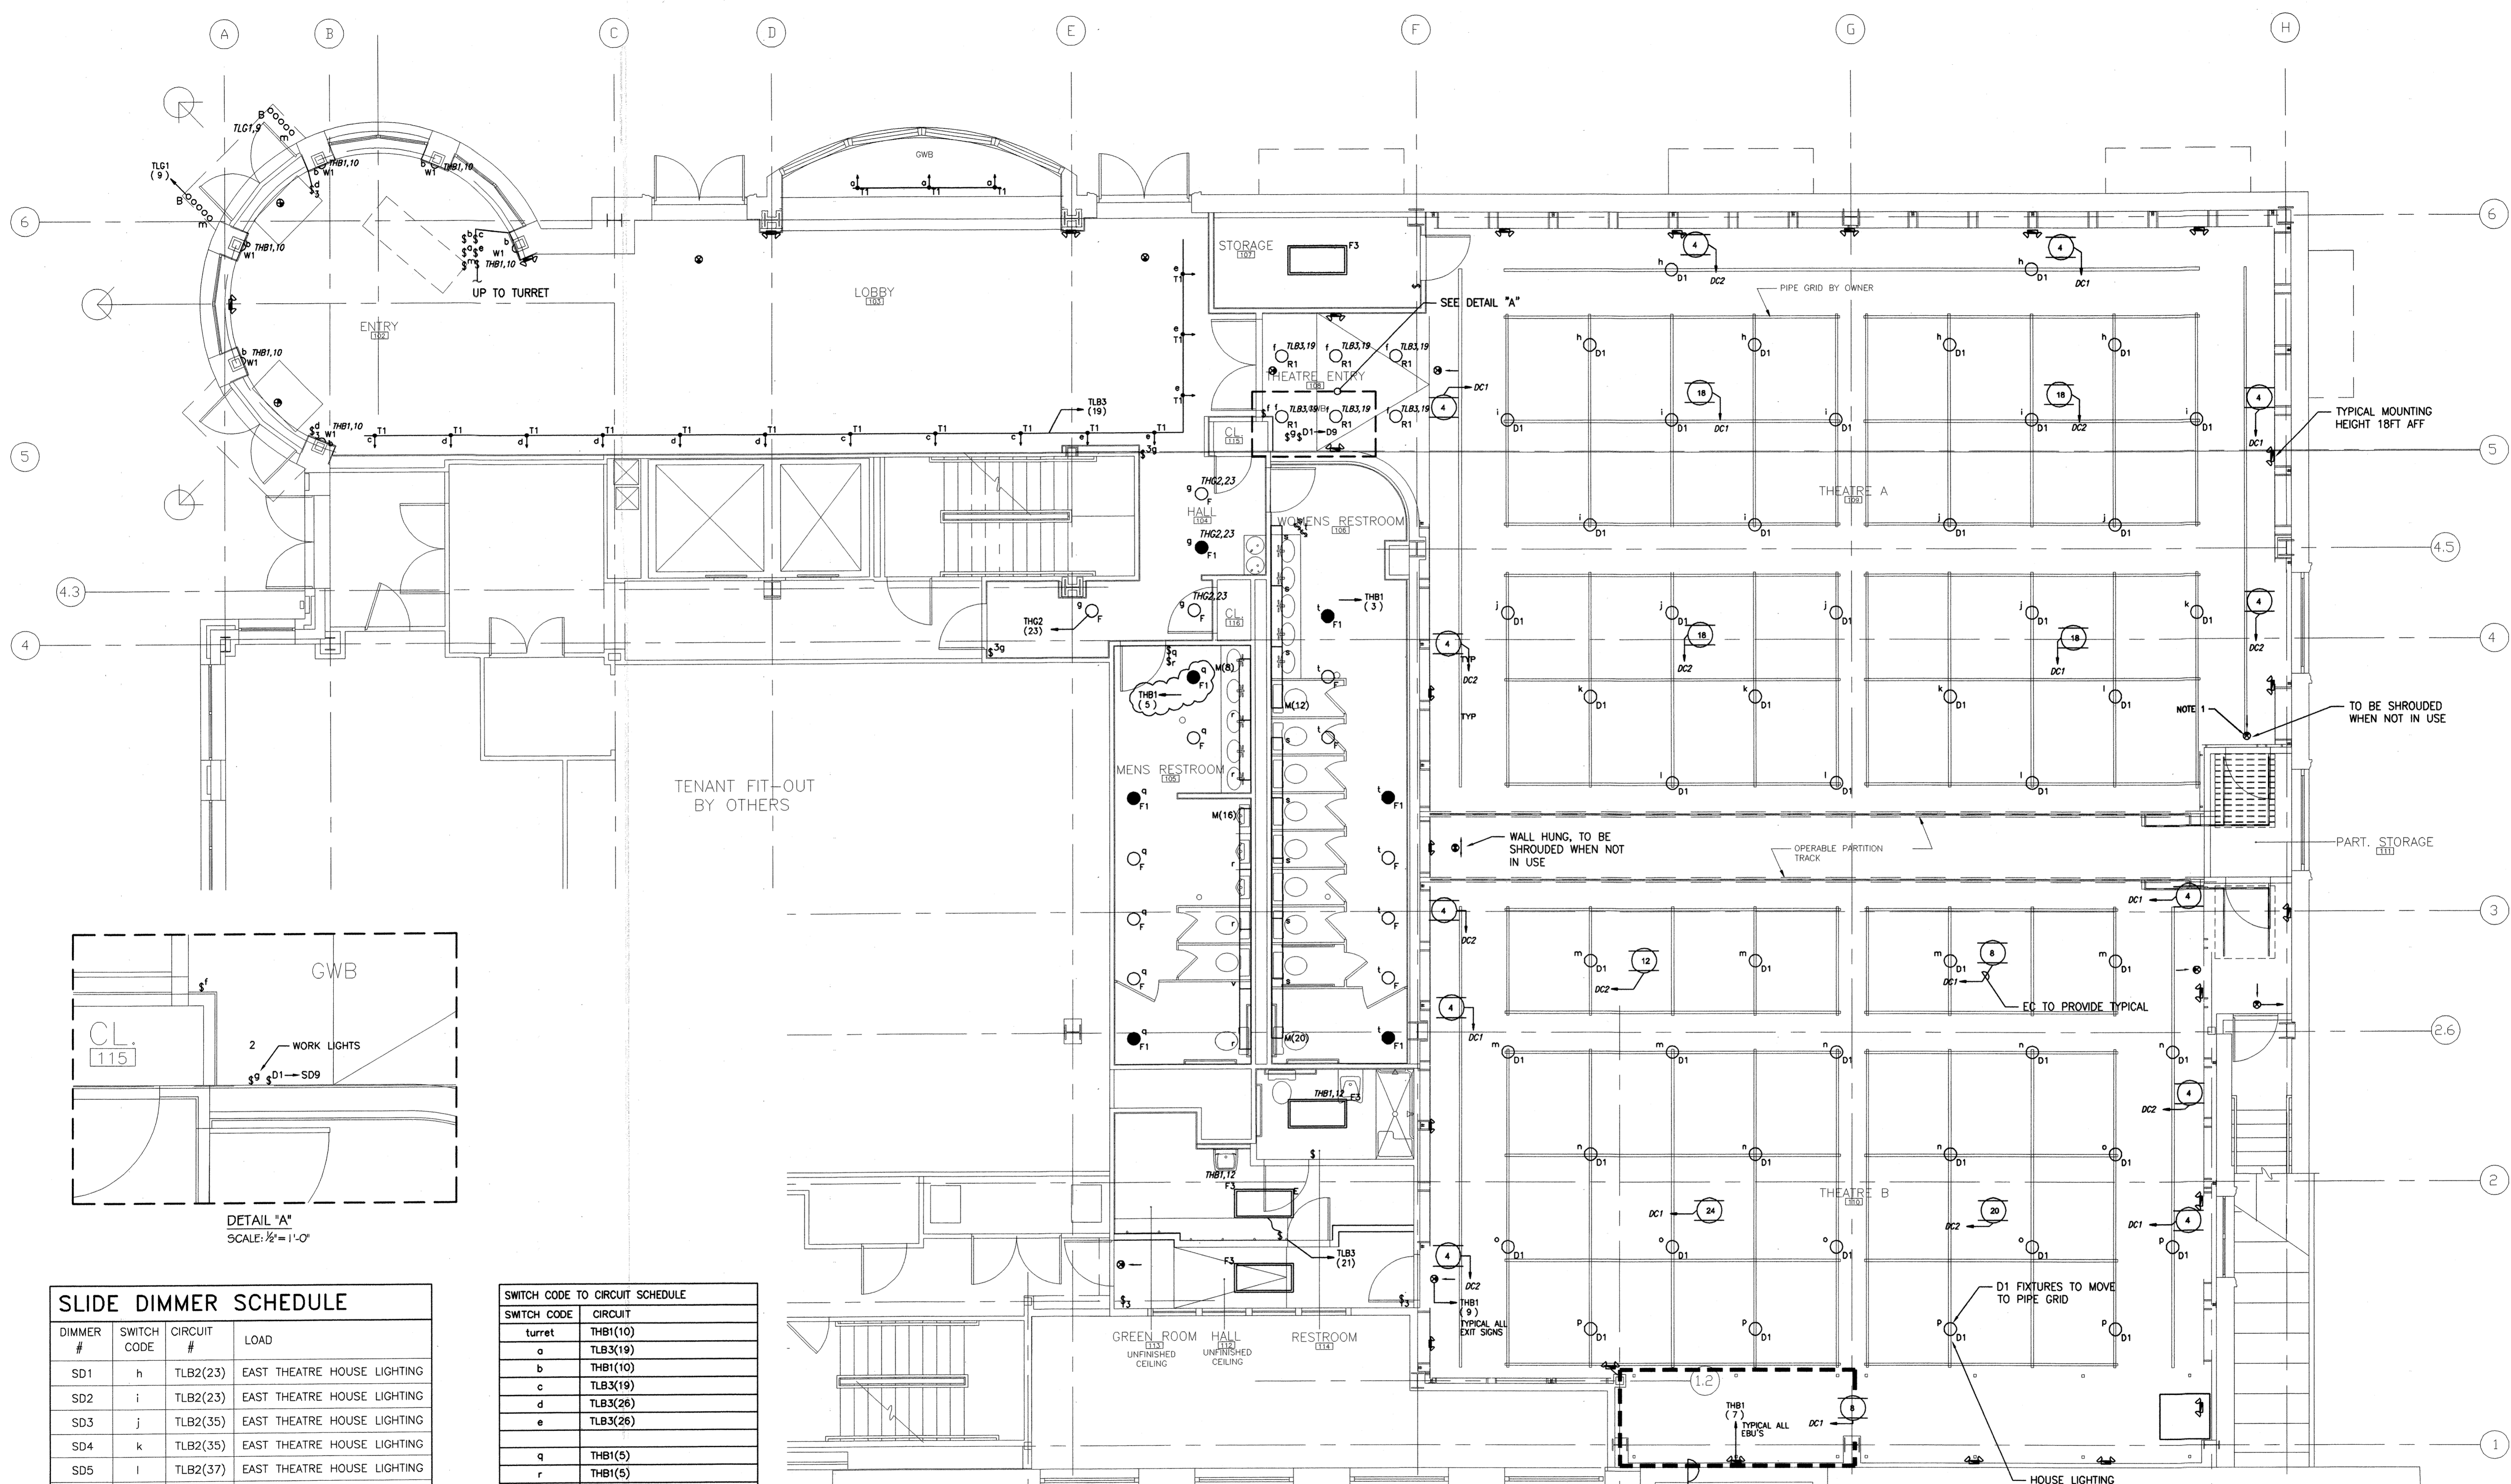

SLIDE DIMMER SCHEDULE

DIMMER #	SWITCH CODE	CIRCUIT #	LOAD
SD1	h	TLB2(23)	EAST THEATRE HOUSE LIGHTING
SD2	i	TLB2(23)	EAST THEATRE HOUSE LIGHTING
SD3	j	TLB2(35)	EAST THEATRE HOUSE LIGHTING
SD4	k	TLB2(35)	EAST THEATRE HOUSE LIGHTING
SD5	l	TLB2(37)	EAST THEATRE HOUSE LIGHTING
SD6	m	TLB2(37)	WEST THEATRE HOUSE LIGHTING
SD7	n	TLB2(39)	WEST THEATRE HOUSE LIGHTING
SD8	o	TLB2(39)	WEST THEATRE HOUSE LIGHTING
SD9	p	TLB2(41)	WEST THEATRE HOUSE LIGHTING




SWITCH CODE TO CIRCUIT SCHEDULE

SWITCH CODE	CIRCUIT
turret	THB1(10)
a	TLB3(19)
b	THB1(10)
c	TLB3(19)
d	TLB3(26)
e	TLB3(26)
q	THB1(5)
r	THB1(5)
s	THB1(3)
t	THB1(3)

- NOTES:**
- EC SHALL CONFIRM THE LOCATIONS OF ALL EXIT SIGNS WITH ARCHITECT.
 - CONTROL OF THEATRICAL LIGHTING BY LOW VOLTAGE SYSTEM/ DIMMER CABINETS.
 - NOT USED.
 - NOT USED.
 - EC SHALL CARRY THE COST OF ONE WORK LIGHT & SWITCH AT DIMMER CABINETS.
 - EXTERIOR EMERGENCY LIGHTING (NOT SHOWN) IS TO BE PROVIDED UNDER THE BASE BUILDING CONSTRUCTION.
 - "D1" FIXTURES TO BE USED FOR "HOUSE LIGHTING". EC SHALL PROVIDE STANDARD SLIDE TYPE DIMMERS. EC SHALL CONFIRM THE DIMMER WATTAGE IS AT LEAST 80% OF THE INSTALLED ZONE WATTAGE.

GENERAL NOTES (ELECTRIC)

HEADSET JACK AT EACH DMX LOCATION
 PROVIDE BATTERY POWERED EMERGENCY LIGHTS
 POWER OUTLETS AT FLOOR LEVEL TO BE 3" O.C. A.F.F.
 AUDIO AT CEILING LEVEL TO BE +/- 26'-0" A.F.F.

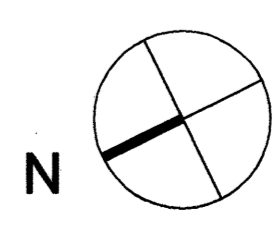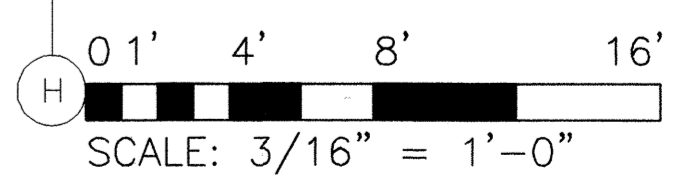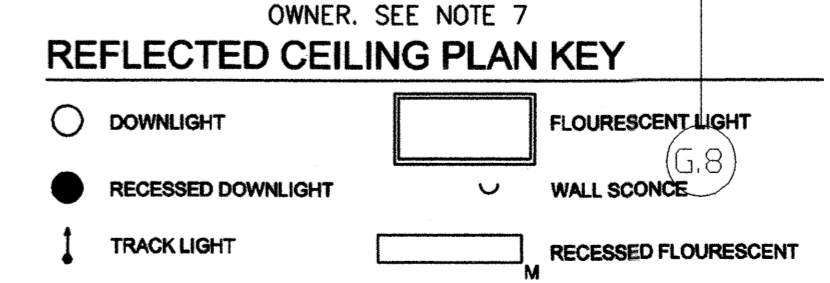

Allied Consulting Engineering Services, Inc.
 215 Boston Post Road, Sudbury, MA
 (978) 443-7888
 FAX (978) 443-4636

SET	DATE

CURRENT ISSUE:

SET	DATE
RECORD DRAWINGS	04.30.05

DRAWING TITLE:

FIRST FLOOR LIGHTING PLAN ELECTRICAL

E4

F:\24030-39\24032\ELEC\24032-E4.dwg PLOTTED: May 09, 2005 - 2:58pm

06204-0048